


Notes :

1. This drawing is the property and copyright of M/s TAG BUILTART. It shall not be copied or used in any way without their written permission.
2. All drawings are in Feet & Inches and to be read only and not measured.
3. Do not scale the dimensions, follow the written dimensions unless otherwise mentioned.
4. Contractors to verify all site conditions and any condition different or not in coherence with the drawings/details must be immediately informed to the Engineers/Architects.

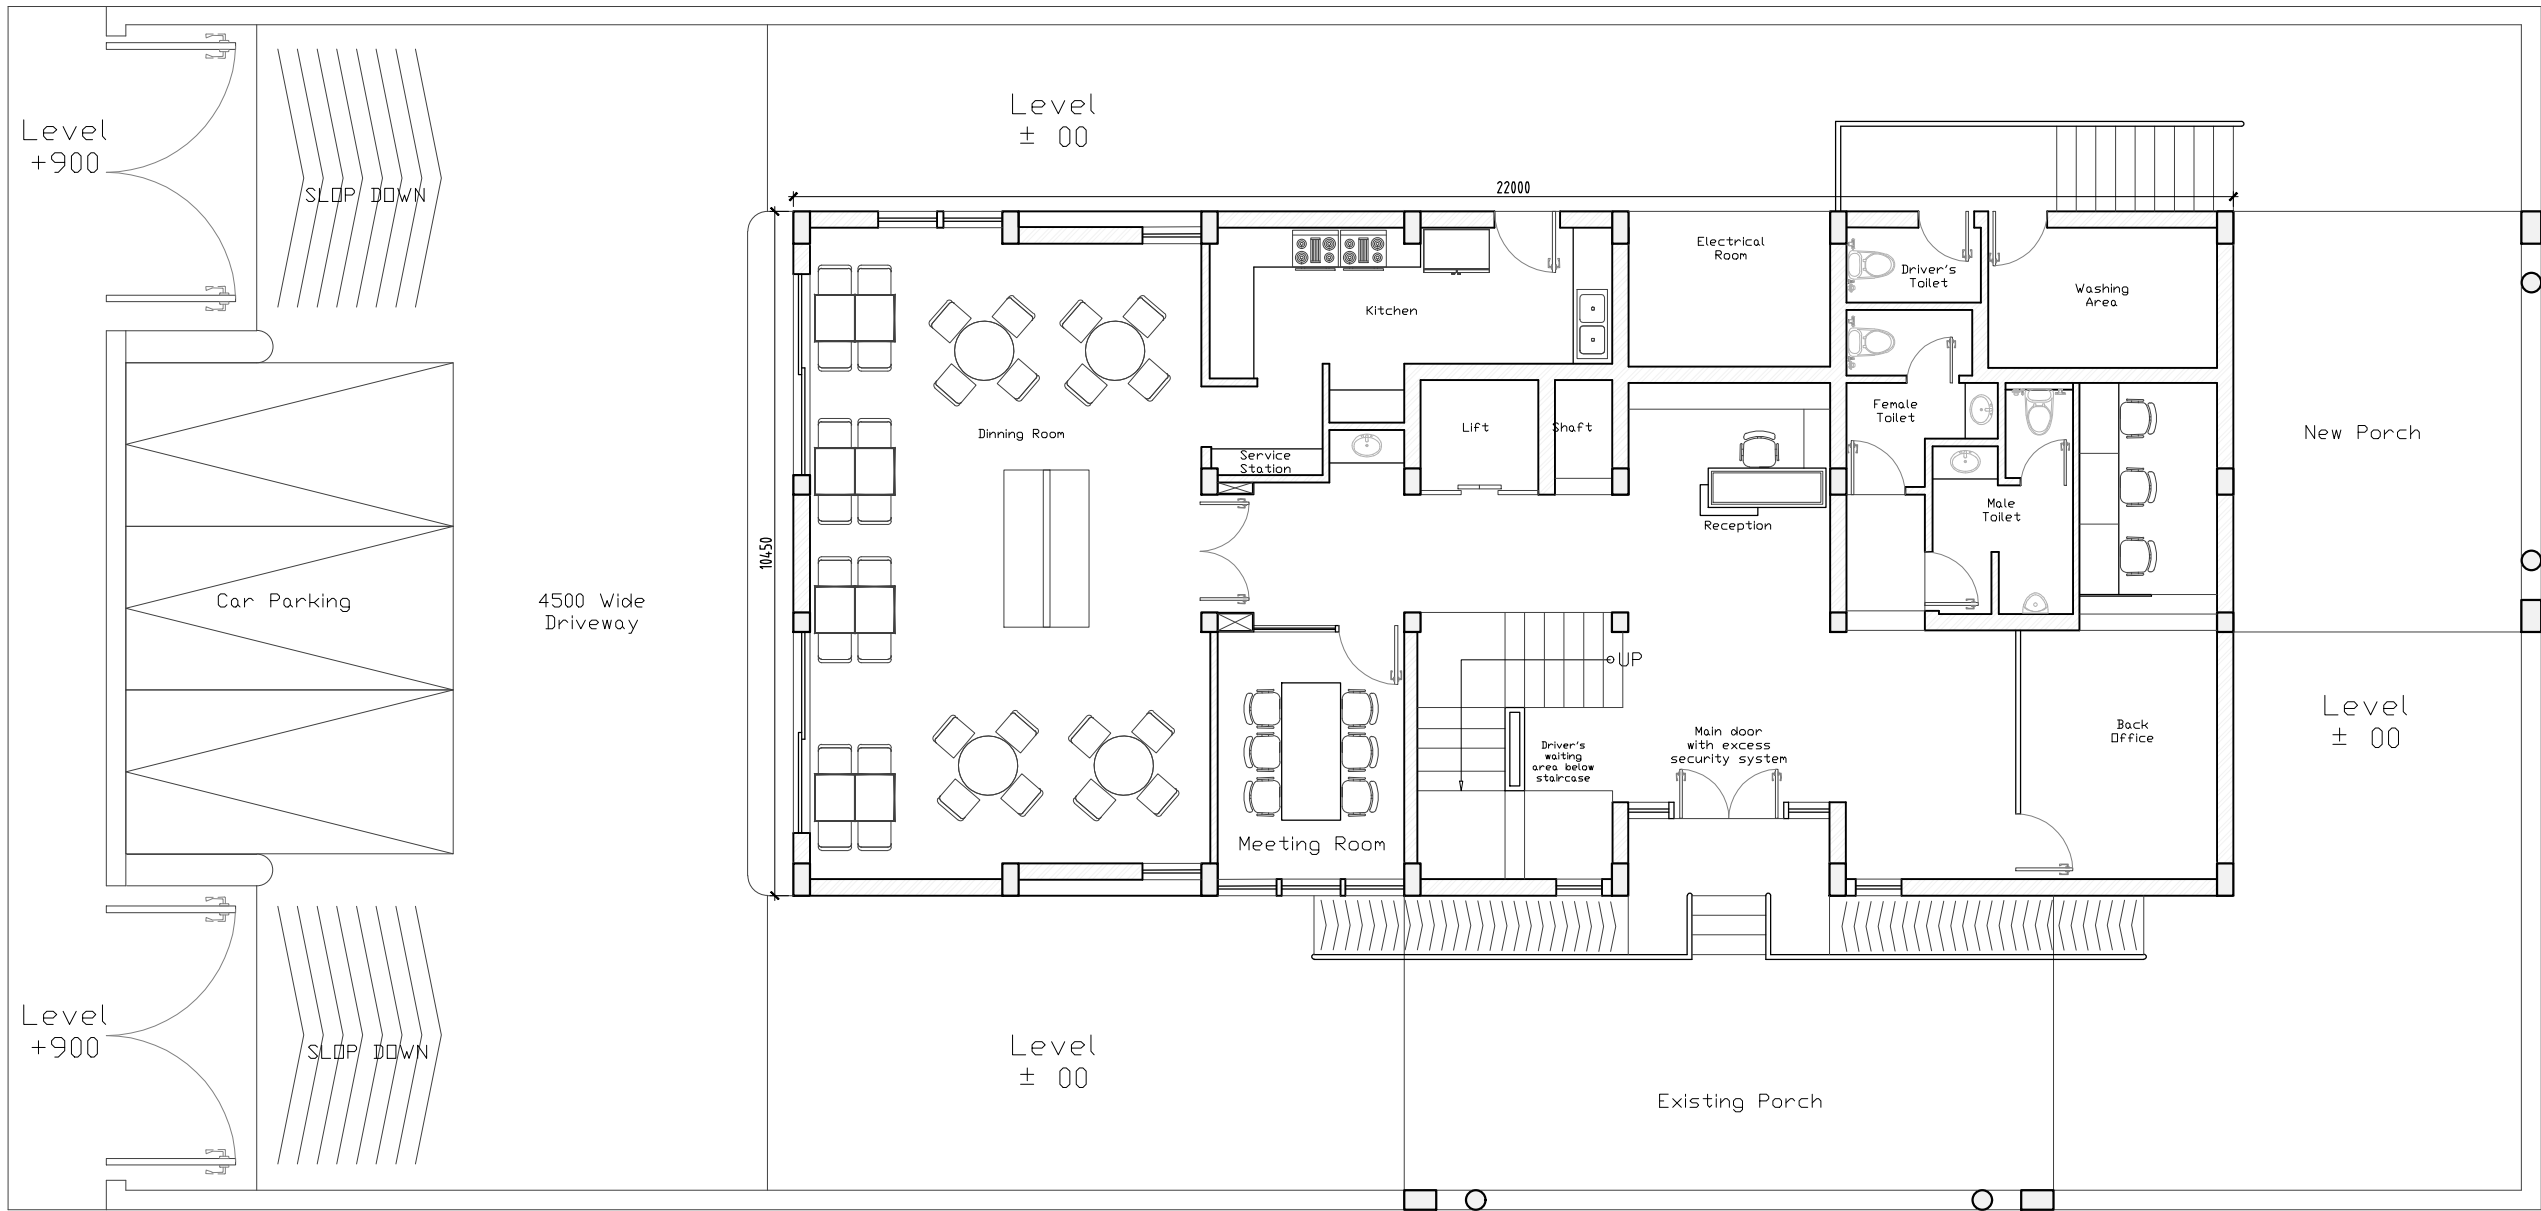

Ground Floor

RO	Tender Docket	22-04-2024	ASM	THB
----	---------------	------------	-----	-----

Rev.	Modification	Date	Drawn	Chkd.
------	--------------	------	-------	-------

CLIENT:
M/s INDIAN PORT ASSOCIATION


PROJECT TITLE
Rest House
Lodhi Road, New Delhi
India

CONSULTANT:
TAG BUILTART
Professionals and Interior Design Consultants
Office No. 322, III Floor Aggarwal Square Plaza, Plot no. 9,
Pocket 7, Sector 12 Dwarka, New Delhi-110078
Mail: info@tagbuiltart.com, Mo: +91 999 919 9201
Web: www.tagbuiltart.com

MEP CONSULTANT:
LEOSCOPE
Consulting Engineers Pvt. Ltd.
H-64, Business Park (Uffim) Sector-63, Noida-201307
Mail: hvacdesign2010@gmail.com
Mo No. : +91 971 132 3995

DRAWING TITLE
Site Plan
Rest House
Tender Docket

SCALE	DRAWN	APM	DATE	PROJECT NO.
M SHEET:- 1:150	CHECKED	THB	22-04-2024	170
A3 SHEET:- 1:100				
DRAWING NO.	NORTH	REV.		
IPA-ARC-DWG-AR-1041		0		
CAD FILE REF. 01-SITE PLAN				

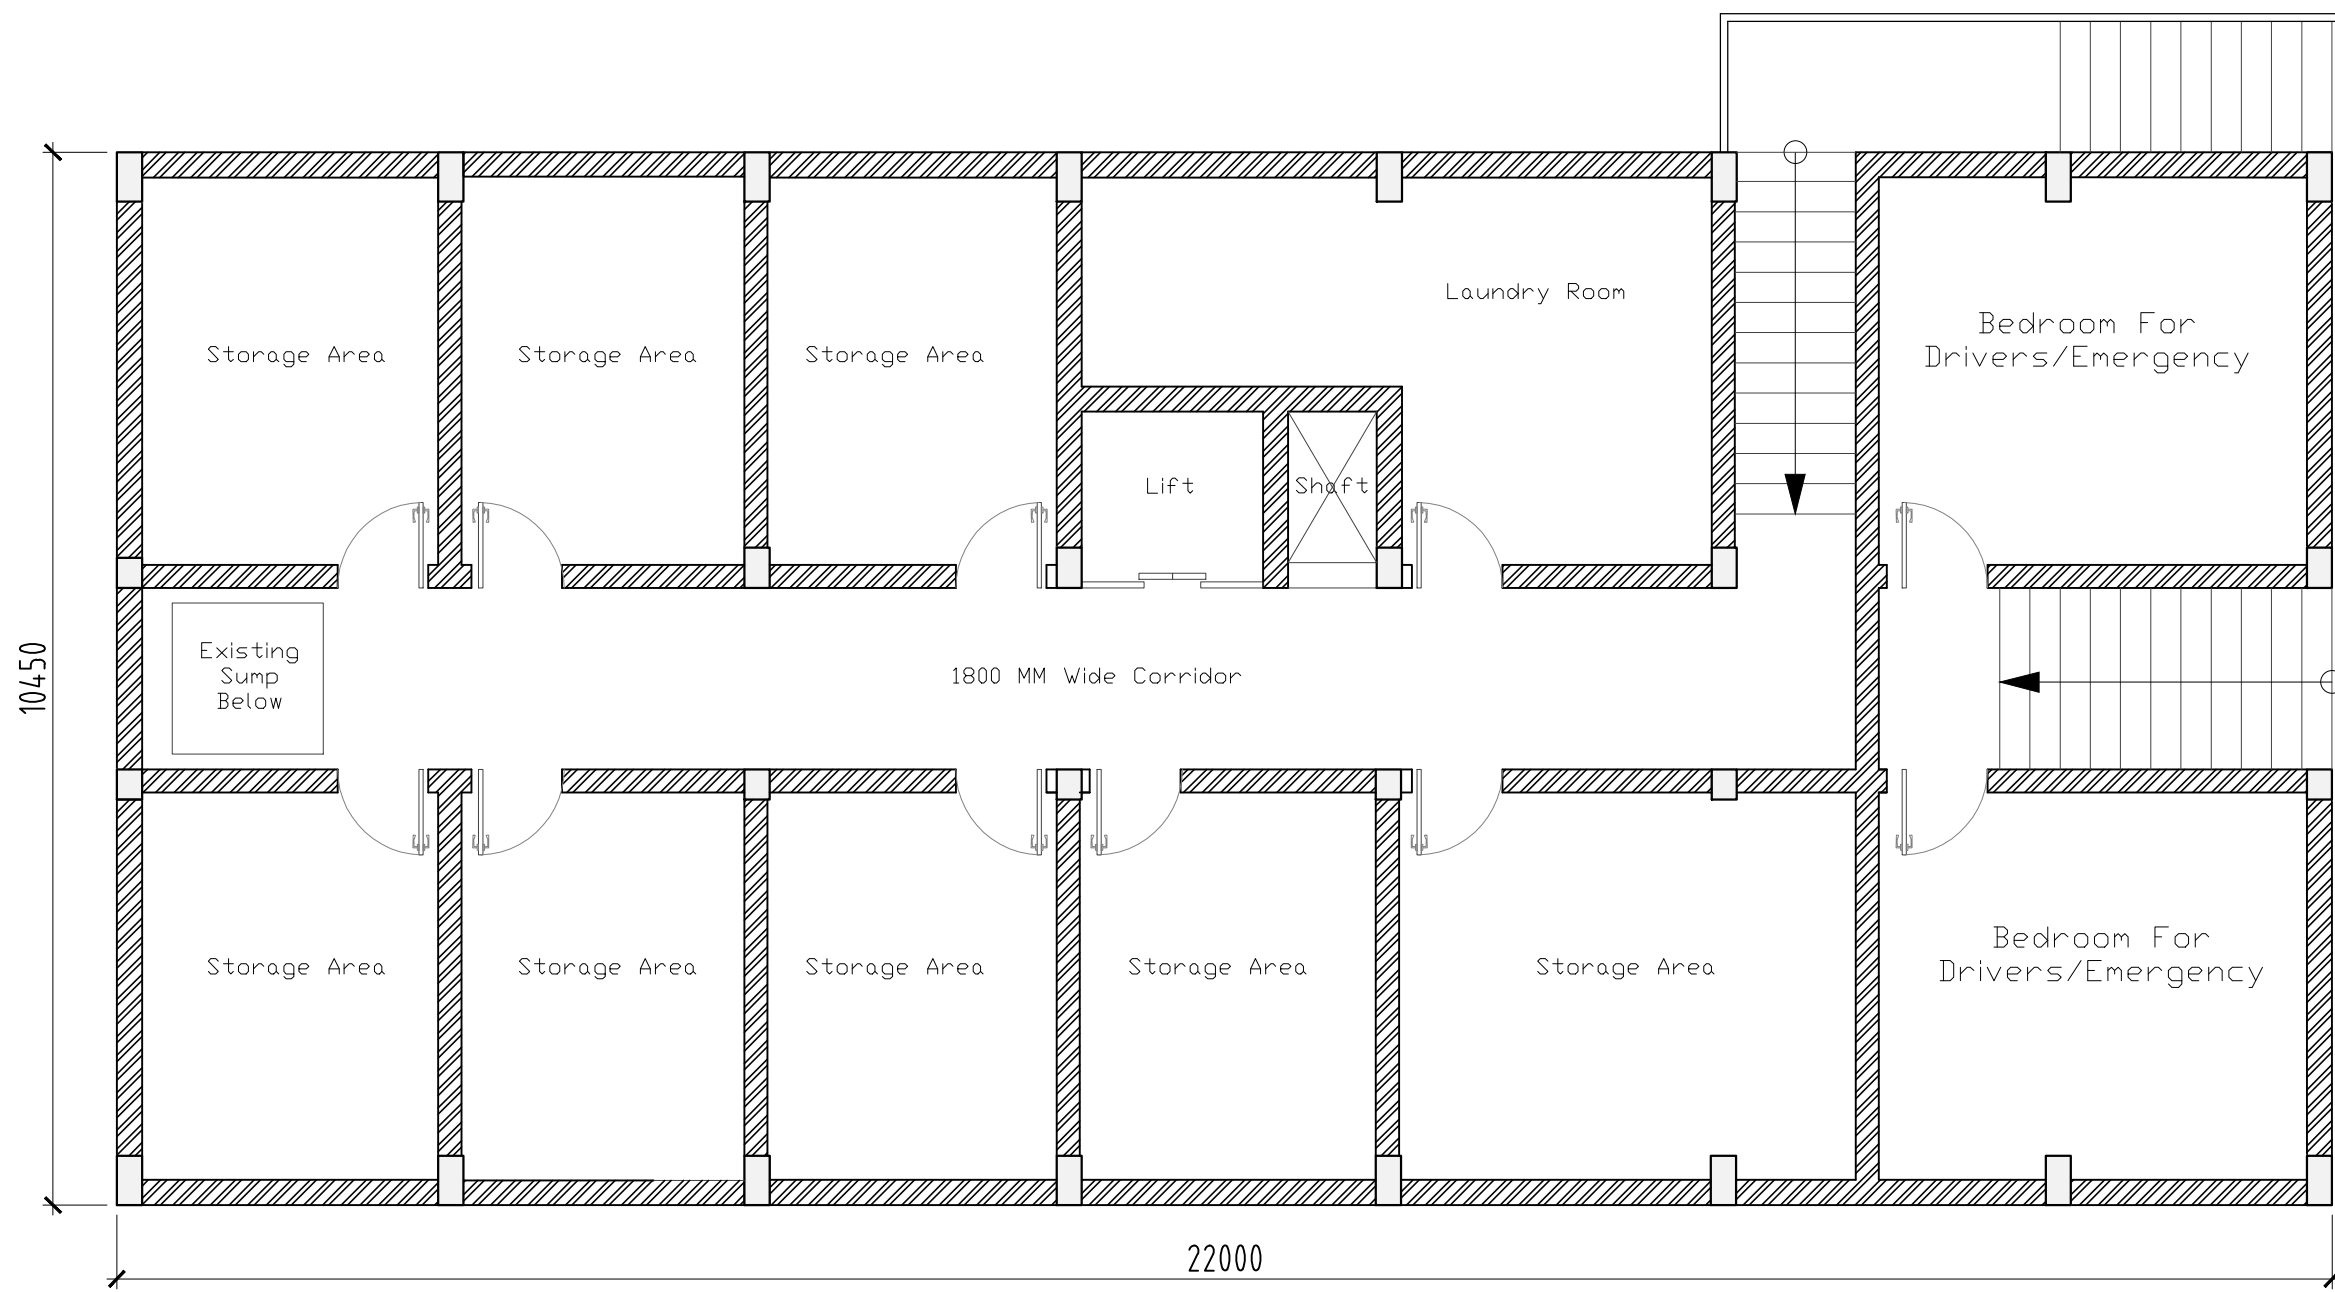

Notes :

1. This drawing is the property and copyright of M/s TAG BUILTART. It shall not be copied or used in any way without their written permission.
2. All drawings are in Feet & Inches and to be read only and not measured.
3. Do not scale the dimensions, follow the written dimensions unless otherwise mentioned.
4. Contractors to verify all site conditions and any condition different or not in coherence with the drawings/details must be immediately informed to the Engineers/Architects.

Rev.	Modification	Date	Drawn	Chkd.
RO	Tender Docket	22-04-2024	ASM	THB

CLIENT:
M/s INDIAN PORT ASSOCIATION

PROJECT TITLE
Rest House
Lodhi Road, New Delhi
India

CONSULTANT:
TAG BUILTART
Architecture and Interior Design Consultants
Office No. 322, III Floor Aggarwal Square Plaza, Plot no. 9,
Pocket 7, Sector 12 Dwarka, New Delhi-110078
Mail: info@tagbuiltart.com, Mb: +91 999 919 9201
Web: www.tagbuiltart.com


MEP CONSULTANT:
 Consulting Engineers Pvt. Ltd.
H-64, Business Park (Uffim) Sector-63, Noida-201307
Mail: hvacdesign2010@gmail.com
Mb No. : +91 971 132 3995
LEOSCOPE

DRAWING TITLE
Basement
Rest House
Tender Docket

SCALE	DRAWN	APM	DATE	PROJECT NO.
M SHEET:- 1:150	CHECKED	THB	22-04-2024	170
A3 SHEET:- 1:100				
DRAWING NO.	NORTH		REV.	
IPA-ARC-DWG-AR-1042			0	
CAD FILE REF:-BASEMENT				

Notes :

1. This drawing is the property and copyright of M/s TAG BUILTART. It shall not be copied or used in any way without their written permission.
2. All drawings are in Feet & Inches and to be read only and not measured.
3. Do not scale the dimensions, follow the written dimensions unless otherwise mentioned.
4. Contractors to verify all site conditions and any condition different or not in coherence with the drawings/details must be immediately informed to the Engineers/Architects.

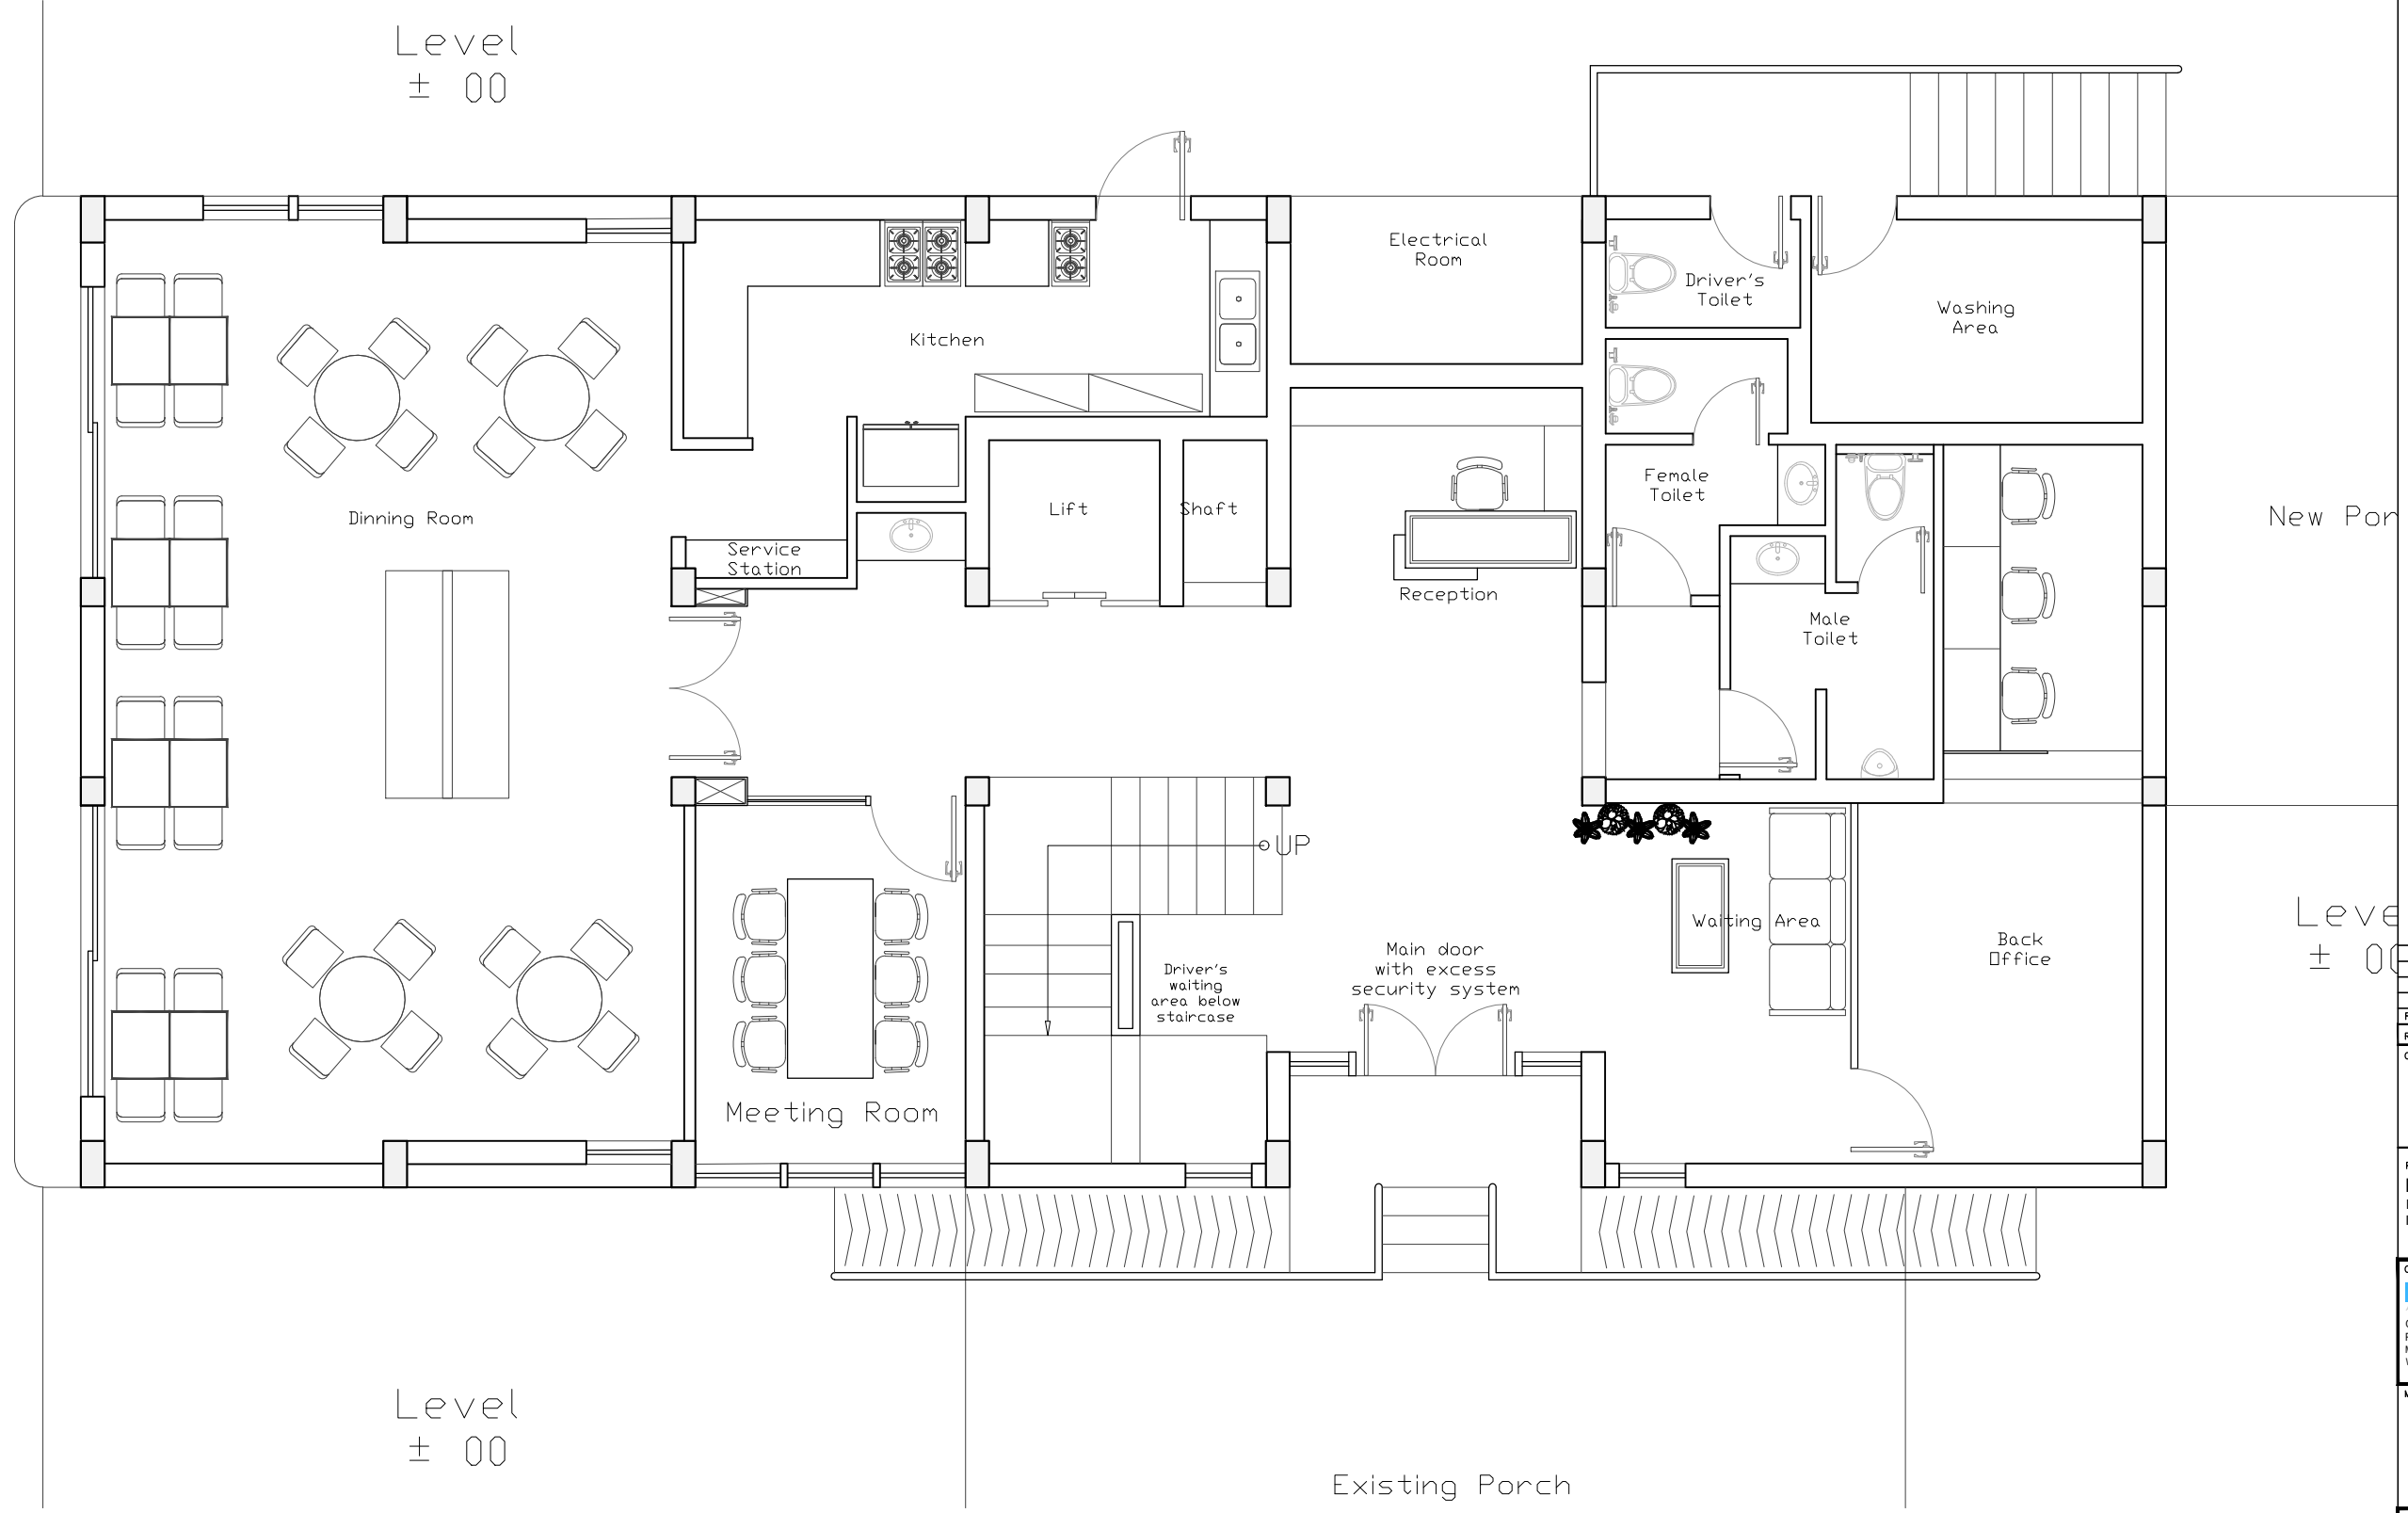

New Port

Level
± 00

Existing Porch

RO	Tender Docket	22-04-2024	ASM	THB
Rev.	Modification	Date	Drawn	Chkd.

CLIENT:
M/s INDIAN PORT ASSOCIATION

PROJECT TITLE
Rest House
Lodhi Road, New Delhi
India

CONSULTANT:
TAG BUILTART
Profession and Interior Design Consultants
Office No. 322, III Floor Aggarwal Square Plaza, Plot no. 9,
Pocket 7, Sector 12 Dwarka, New Delhi-110078
Mail: info@tagbuiltart.com, Mb: +91 999 919 9201
Web: www.tagbuiltart.com


MEP CONSULTANT:
 Consulting Engineers Pvt. Ltd.
H-64, Business Park (Uffim) Sector-63, Noida-201307
Mail: hvacdesign2010@gmail.com
Mb No. : +91 971 132 3995
LEOSCOPE

DRAWING TITLE
Ground Floor
Rest House
Tender Docket

SCALE	DRAWN	APM	DATE	PROJECT NO.
M SHEET:- 1:150	CHECKED	THB	22-04-2024	170
A3 SHEET:- 1:100				
DRAWING NO.	NORTH	REV.		
IPA-ARC-DWG-AR-1042		0		
CAD FILE REF.03-GROUND FLOOR				

Notes :

1. This drawing is the property and copyright of M/s TAG BUILTART. It shall not be copied or used in any way without their written permission.
2. All drawings are in Feet & Inches and to be read only and not measured.
3. Do not scale the dimensions, follow the written dimensions unless otherwise mentioned.
4. Contractors to verify all site conditions and any condition different or not in coherence with the drawings/details must be immediately informed to the Engineers/Architects.

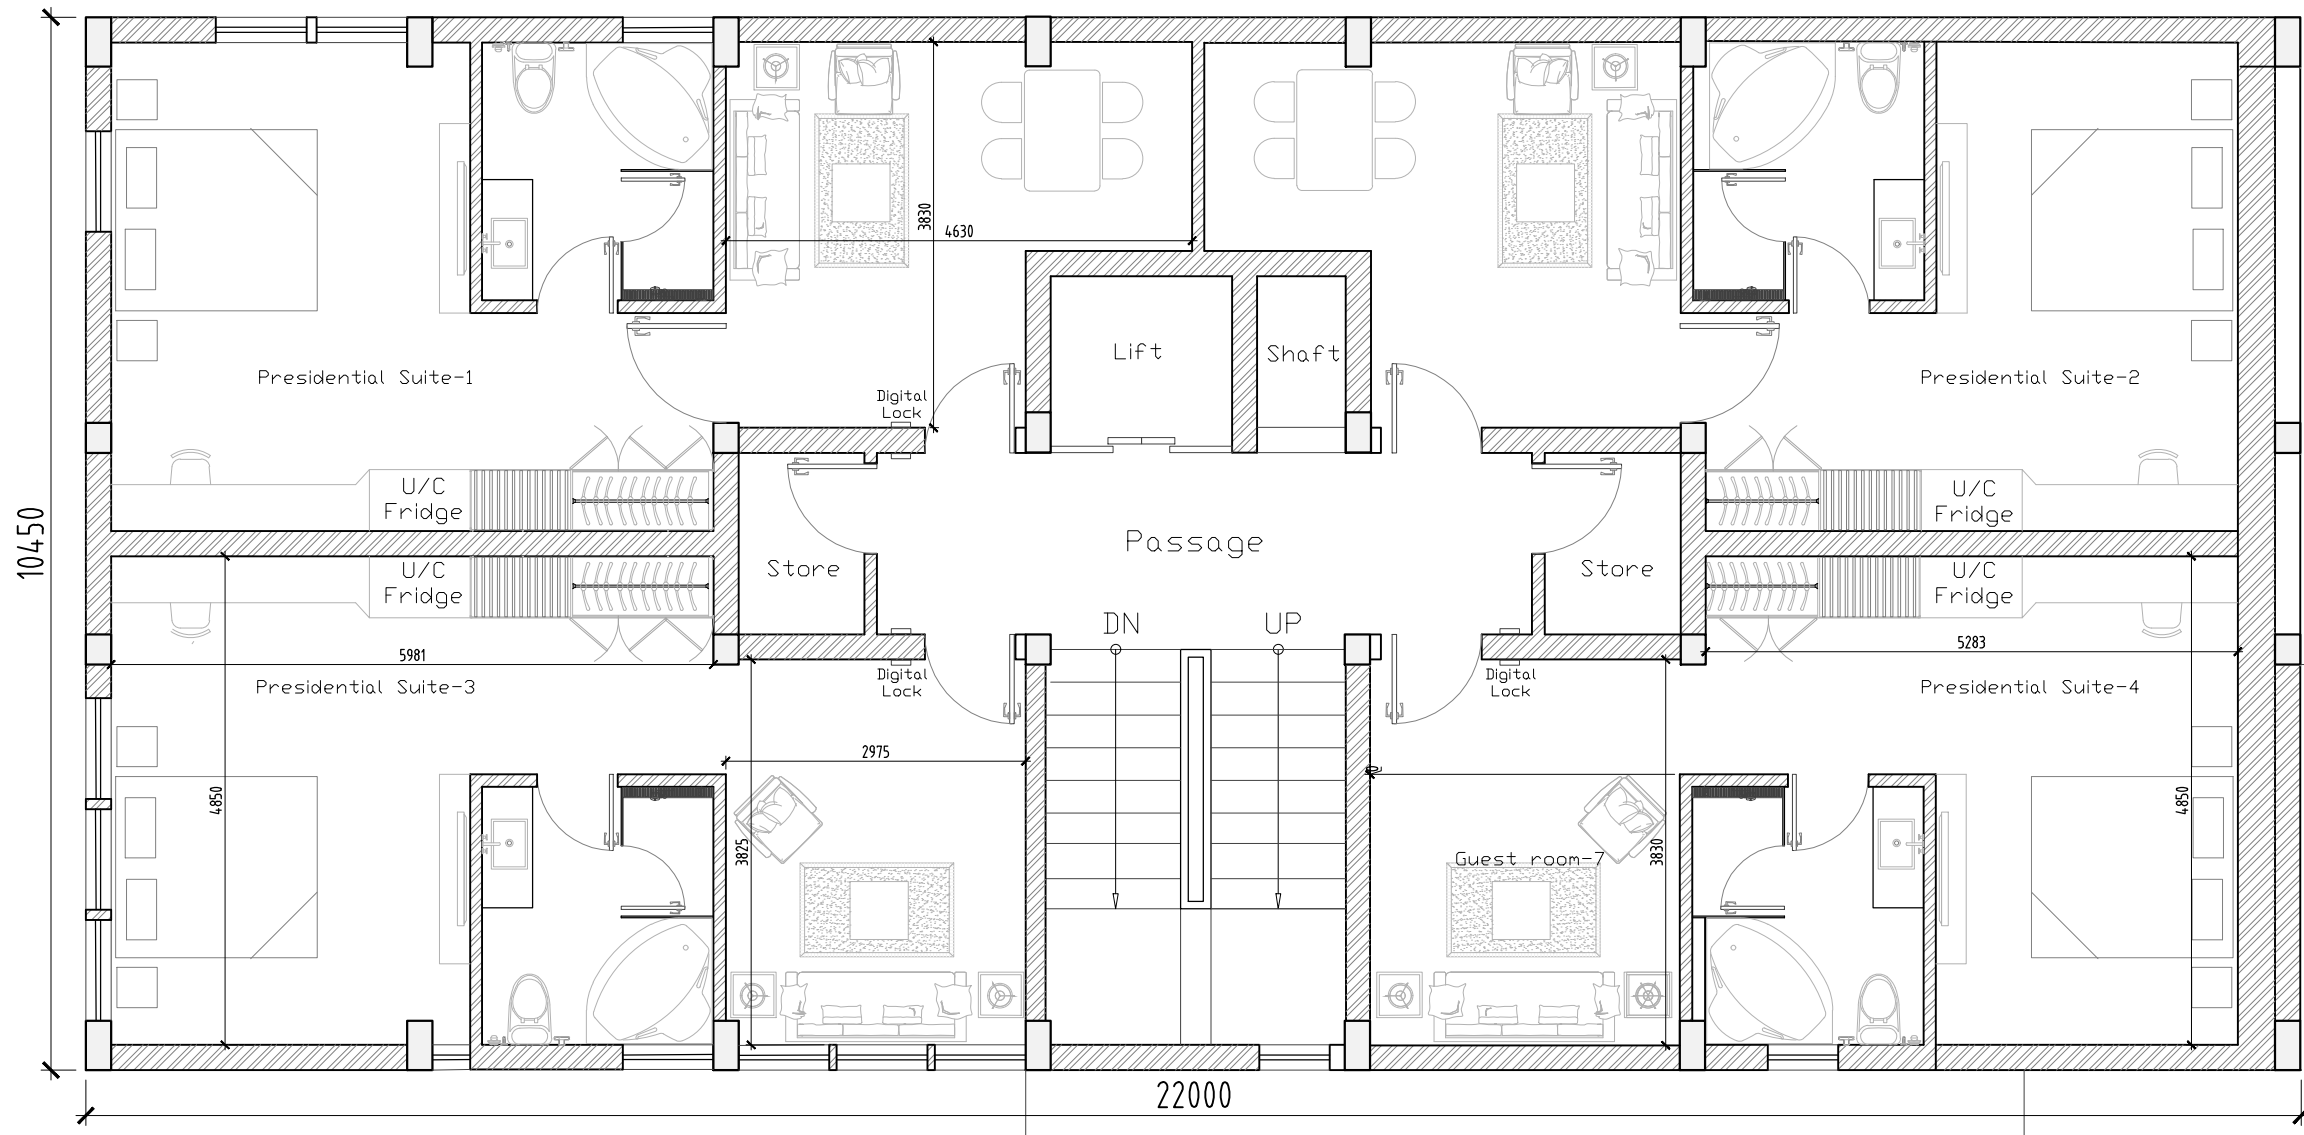

RO	Tender Docket	22-04-2024	ASM	THB
Rev.	Modification	Date	Drawn	Chkd.

CLIENT:
M/s INDIAN PORT ASSOCIATION

PROJECT TITLE
Rest House
Lodhi Road, New Delhi
India

CONSULTANT:
TAG BUILTART
Professionals and Interior Design Consultants
Office No. 322, III Floor Aggarwal Square Plaza, Plot no. 9,
Pocket 7, Sector 12 Dwarka, New Delhi-110078
Mail: info@tagbuiltart.com, Mb: +91 999 919 9201
Web: www.tagbuiltart.com


MEP CONSULTANT:
 Consulting Engineers Pvt. Ltd.
H-64, Business Park (Uffim) Sector-63, Noida-201307
Mail: hvacdesign2010@gmail.com
Mb No. : +91 971 132 3995

DRAWING TITLE
First Floor
Rest House
Tender Docket

SCALE	DRAWN	APM	DATE	PROJECT NO.
M SHEET:- 1:150	CHECKED	THB	22-04-2024	170
A3 SHEET:- 1:100	DRAWING NO.	NORTH	REV.	0
IP A-ARC-DWG-AR-1042	CAD FILE REF.04--FIRST FLOOR			

Notes :

1. This drawing is the property and copyright of M/s TAG BUILTART. It shall not be copied or used in any way without their written permission.
2. All drawings are in Feet & Inches and to be read only and not measured.
3. Do not scale the dimensions, follow the written dimensions unless otherwise mentioned.
4. Contractors to verify all site conditions and any condition different or not in coherence with the drawings/details must be immediately informed to the Engineers/Architects.

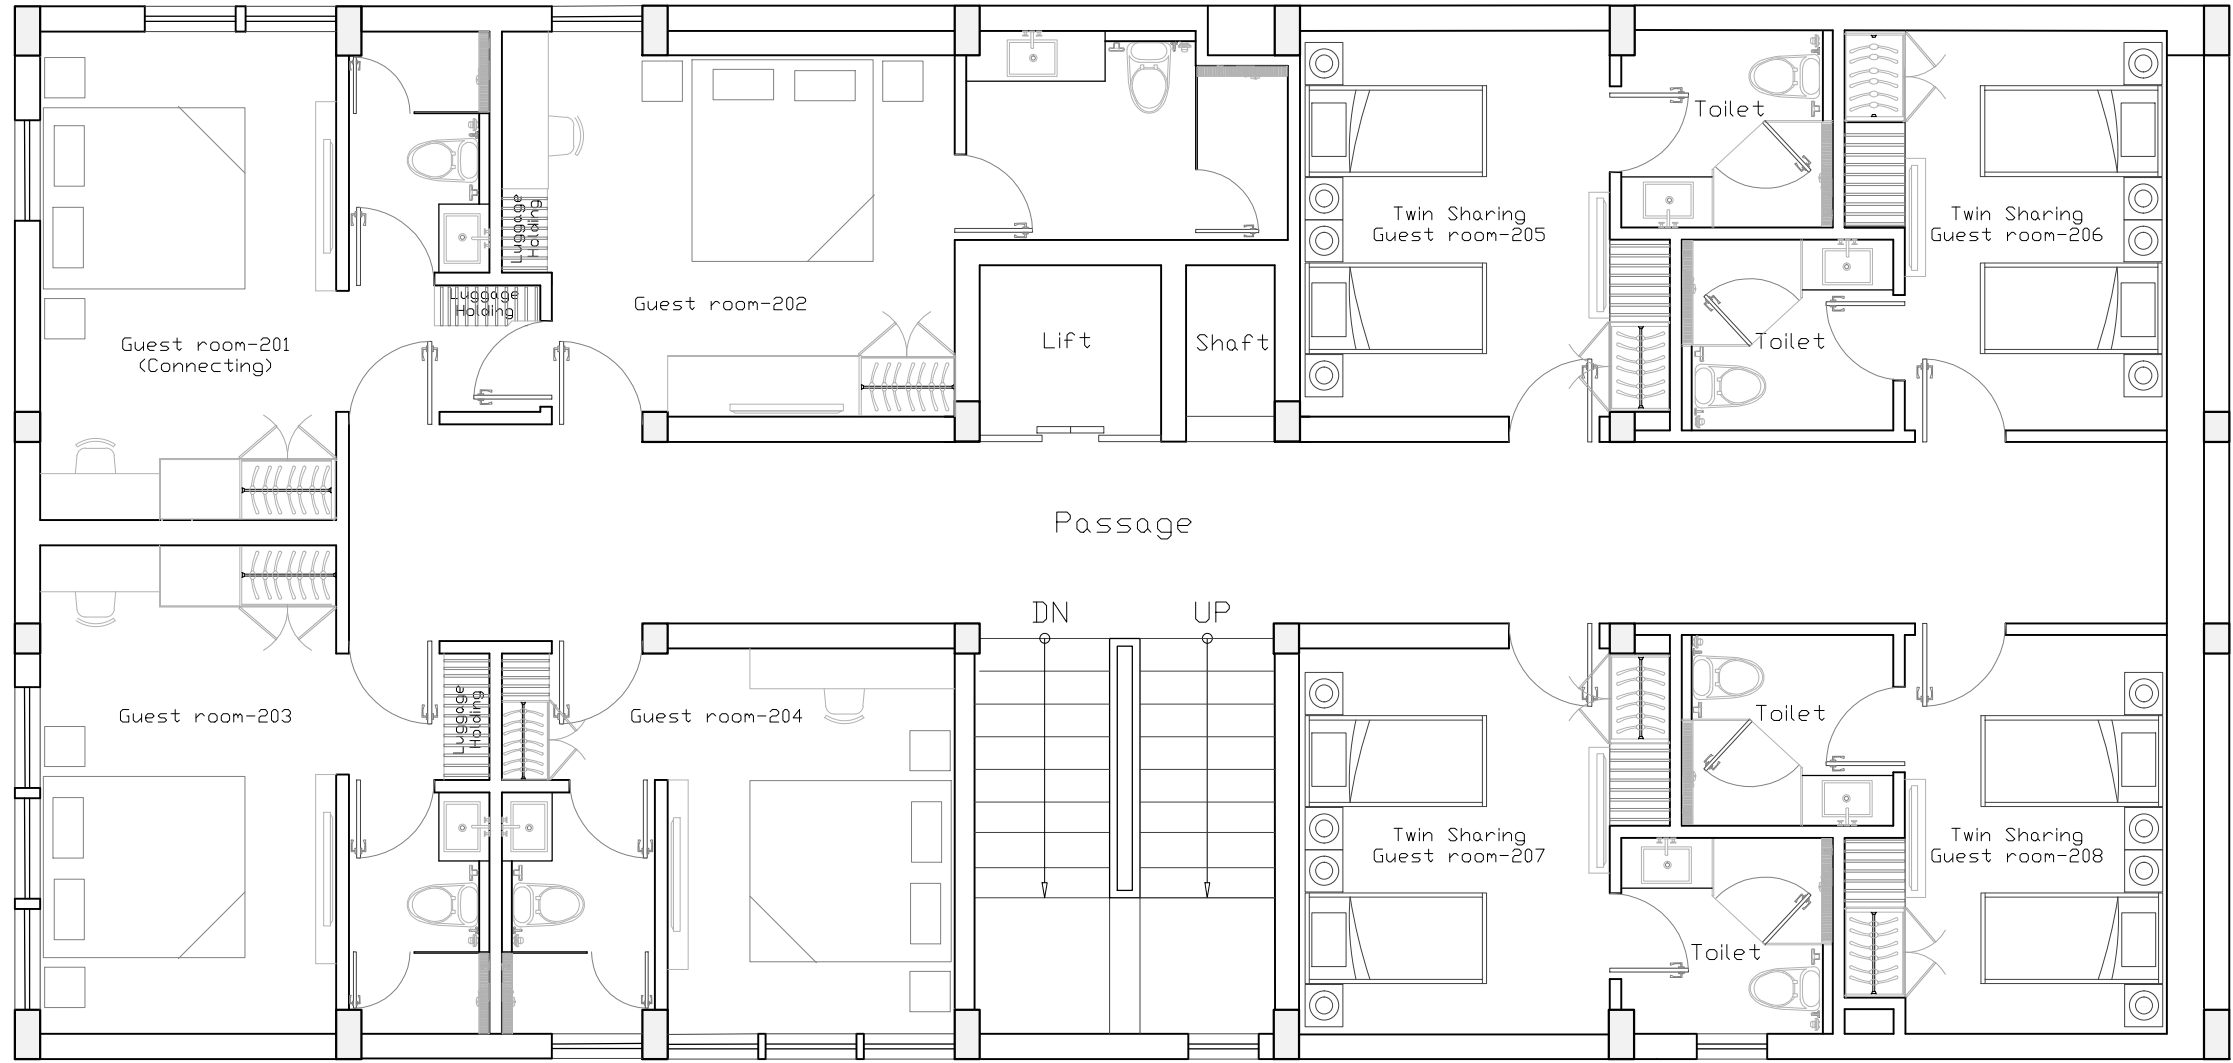

RO	Tender Docket	22-04-2024	ASM	THB
Rev.	Modification	Date	Drawn	Chkd.

CLIENT:

M/s INDIAN PORT ASSOCIATION

PROJECT TITLE
Rest House
 Lodhi Road, New Delhi
 India

CONSULTANT:
TAG BUILTART
 Professionals and Interior Design Consultants
 Office No. 322, III Floor Aggarwal Square Plaza, Plot no. 9,
 Pocket 7, Sector 12 Dwarka, New Delhi-110078
 Mail: info@tagbuiltart.com, Mb: +91 999 919 9201
 Web: www.tagbuiltart.com


MEP CONSULTANT:
 Consulting Engineers Pvt. Ltd.
 H-64, Business Park (Uffim) Sector-63, Noida-201307
 Mail: hvacdesign2010@gmail.com
 Mb No. : +91 971 132 3995
 LEOSCOPE

DRAWING TITLE
Second Floor
Rest House
Tender Docket

SCALE	DRAWN	APM	DATE	PROJECT NO.
M SHEET:- 1:150	CHECKED	THB	22-04-2024	170
A3 SHEET:- 1:100				
DRAWING NO.	NORTH	REV.		
IPA-ARC-DWG-AR-1042		0		
CAD FILE REF.05-SECOND FLOOR				

Notes :

1. This drawing is the property and copyright of M/s TAG BUILTART. It shall not be copied or used in any way without their written permission.
2. All drawings are in Feet & Inches and to be read only and not measured.
3. Do not scale the dimensions, follow the written dimensions unless otherwise mentioned.
4. Contractors to verify all site conditions and any condition different or not in coherence with the drawings/details must be immediately informed to the Engineers/Architects.

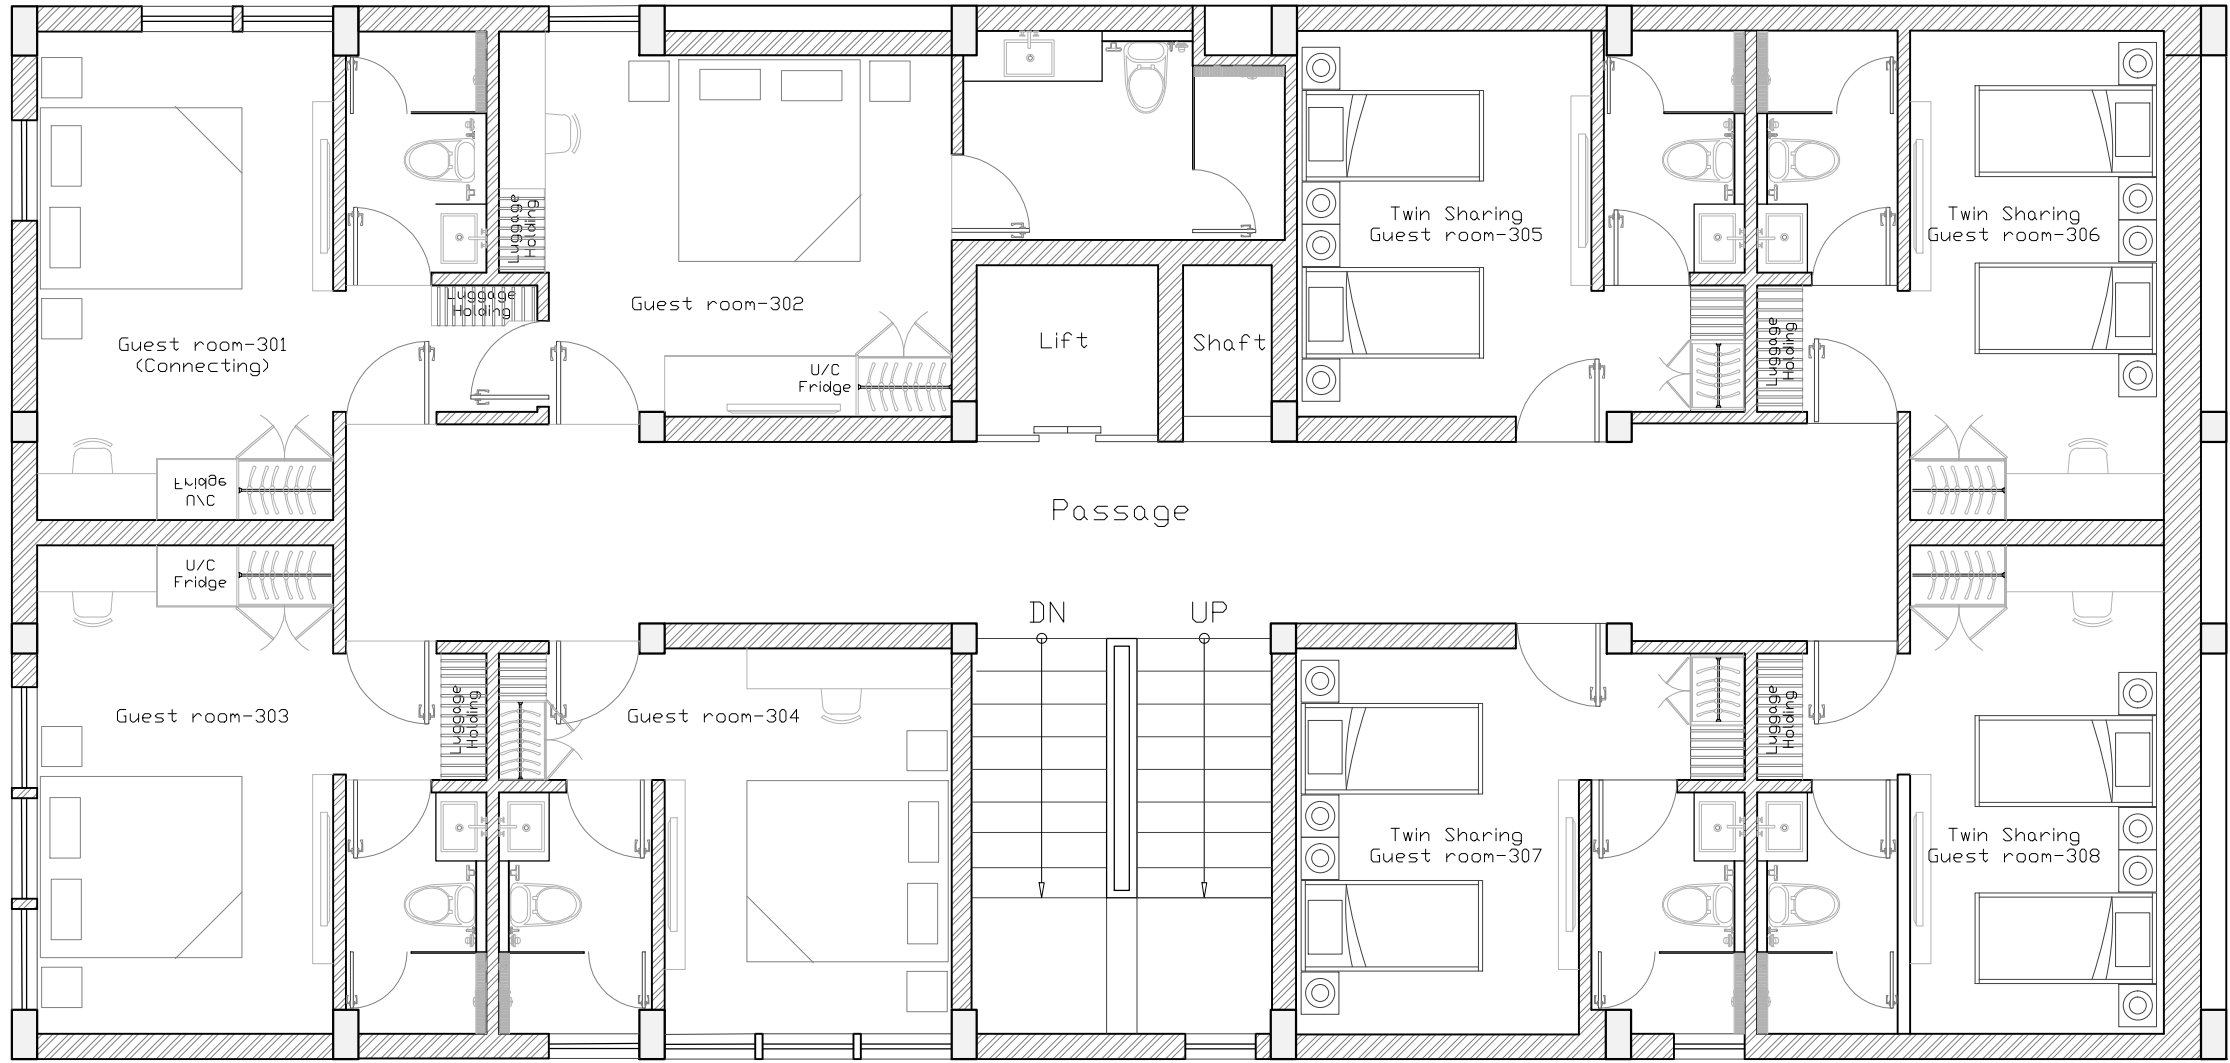

RO	Tender Docket	22-04-2024	ASM	THB
Rev.	Modification	Date	Drawn	Chkd.

CLIENT:

M/s INDIAN PORT ASSOCIATION


PROJECT TITLE
Rest House
 Lodhi Road, New Delhi
 India

CONSULTANT:
TAG BUILTART
Profession and Interior Design Consultants
 Office No. 322, III Floor Aggarwal Square Plaza, Plot no. 9,
 Pocket 7, Sector 12 Dwarka, New Delhi-110078
 Mail: info@tagbuiltart.com, Mb: +91 999 919 9201
 Web: www.tagbuiltart.com

MEP CONSULTANT:
 Consulting Engineers Pvt. Ltd.
 H-64, Business Park (Uffim) Sector-63, Noida-201307
 Mail: hvacdesign2010@gmail.com
 Mb No. : +91 971 132 3995
 LEOSCOPE

DRAWING TITLE
Third Floor
Rest House
Tender Docket

SCALE	DRAWN	DATE	PROJECT NO.
M SHEET:- 1:150	AFM	22-04-2024	170
A3 SHEET:- 1:100	THB		
DRAWING NO.	NORTH	REV.	
IPA-ARC-DWG-AR-1042		0	
CAD FILE REF.06-THIRD FLOOR			

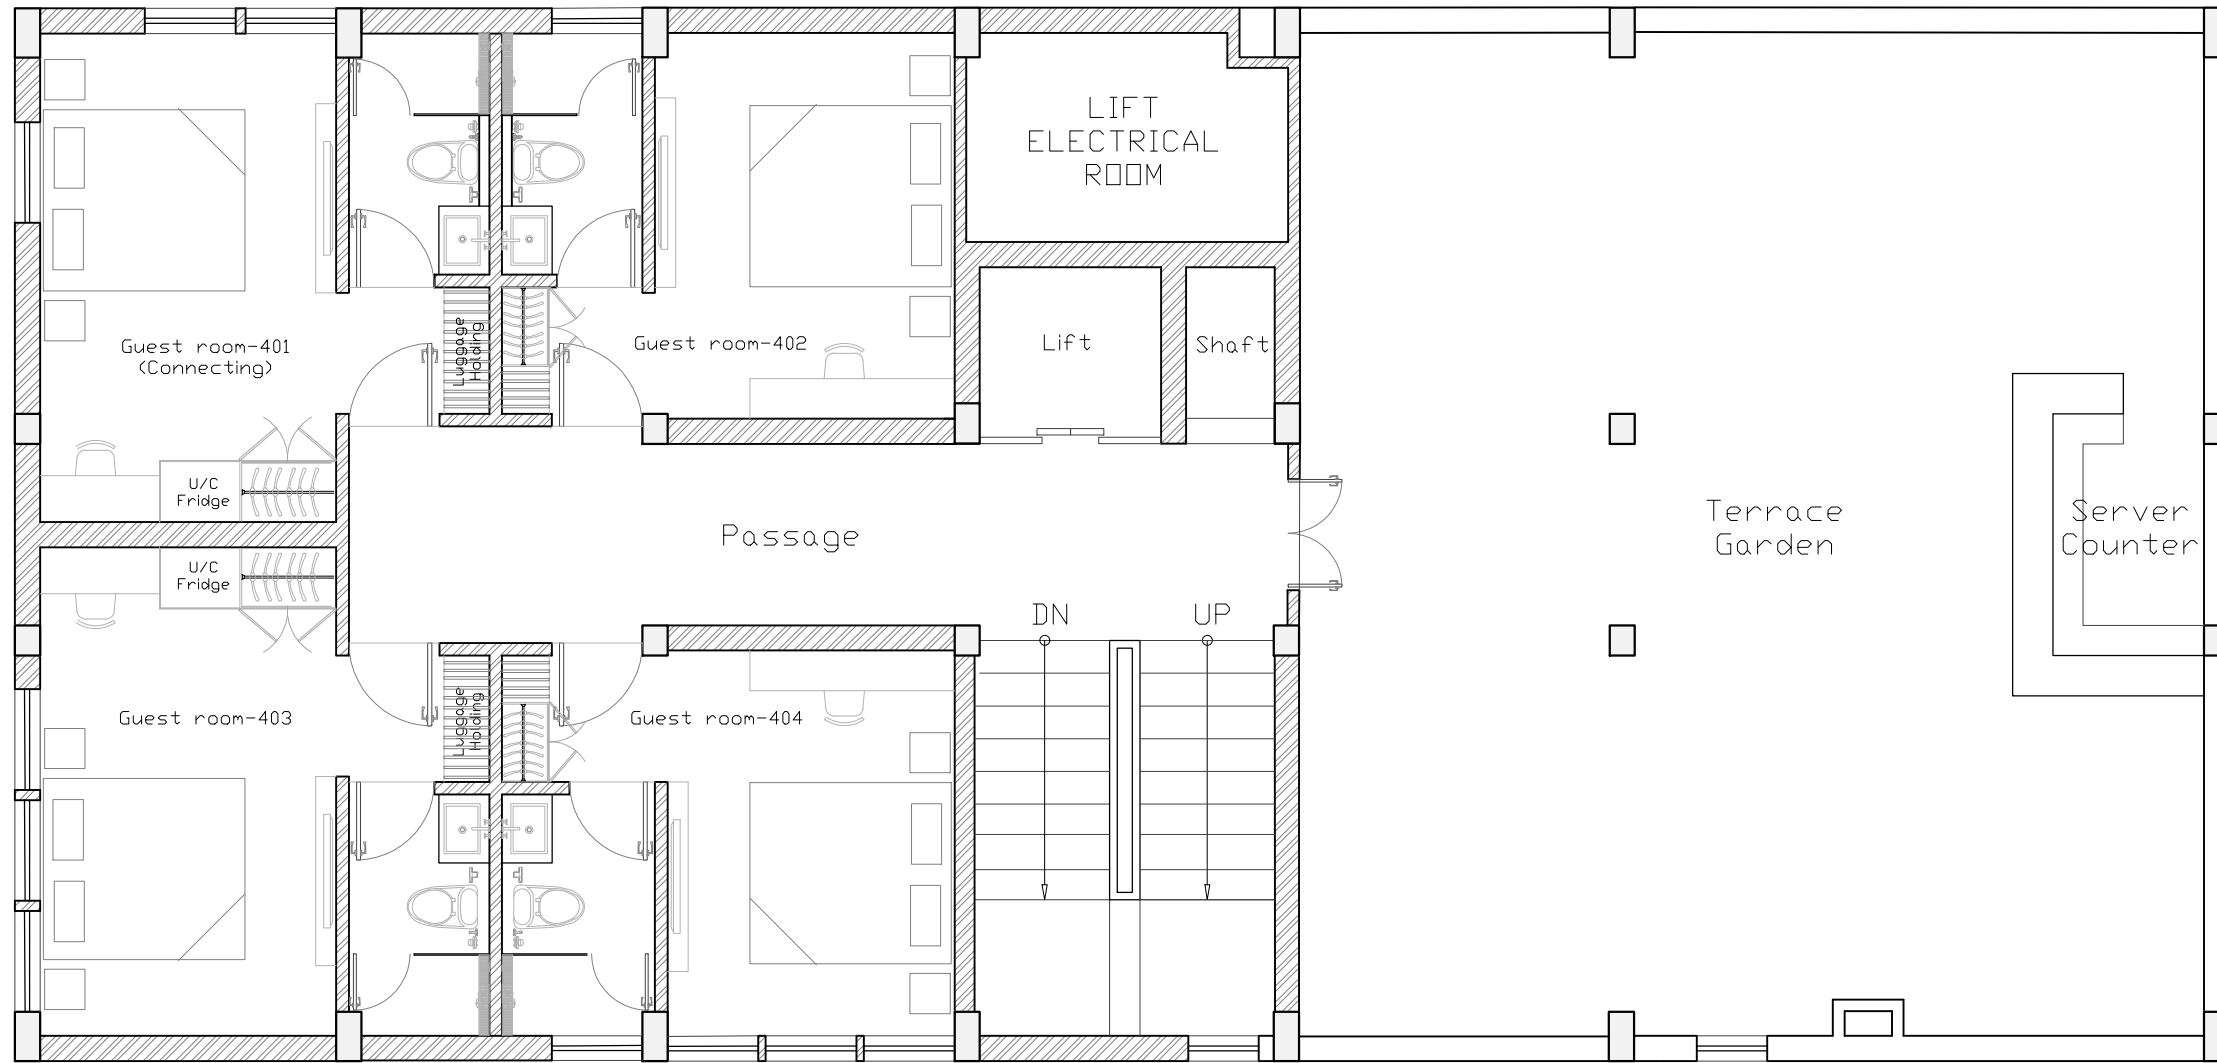

Notes :

1. This drawing is the property and copyright of M/s TAG BUILTART. It shall not be copied or used in any way without their written permission.
2. All drawings are in Feet & Inches and to be read only and not measured.
3. Do not scale the dimensions, follow the written dimensions unless otherwise mentioned.
4. Contractors to verify all site conditions and any condition different or not in coherence with the drawings/details must be immediately informed to the Engineers/Architects.

RO	Tender Docket	22-04-2024	ASM	THB
Rev.	Modification	Date	Drawn	Chkd.

CLIENT:

M/s INDIAN PORT ASSOCIATION


PROJECT TITLE
Rest House
 Lodhi Road, New Delhi
 India

CONSULTANT:
TAG BUILTART
Profession and Interior Design Consultants
 Office No. 322, III Floor Aggarwal Square Plaza, Plot no. 9,
 Pocket 7, Sector 12 Dwarka, New Delhi-110078
 Mail: info@tagbuiltart.com, Mb: +91 999 919 9201
 Web: www.tagbuiltart.com

MEP CONSULTANT:
 Consulting Engineers Pvt. Ltd.
 H-64, Business Park (Uffim) Sector-63, Noida-201307
 Mail: hvacdesign2010@gmail.com
 Mb No. : +91 971 132 3995
 LEOSCOPE

DRAWING TITLE
Fourth Floor
Rest House
Tender Docket

SCALE	DRAWN	APM	DATE	PROJECT NO.
M SHEET:- 1:150	CHECKED	THB	22-04-2024	170
A3 SHEET:- 1:100				
DRAWING NO.	NORTH	REV.		
IPA-ARC-DWG-AR-1042		0		
CAD FILE REF. 07-FOURTH				

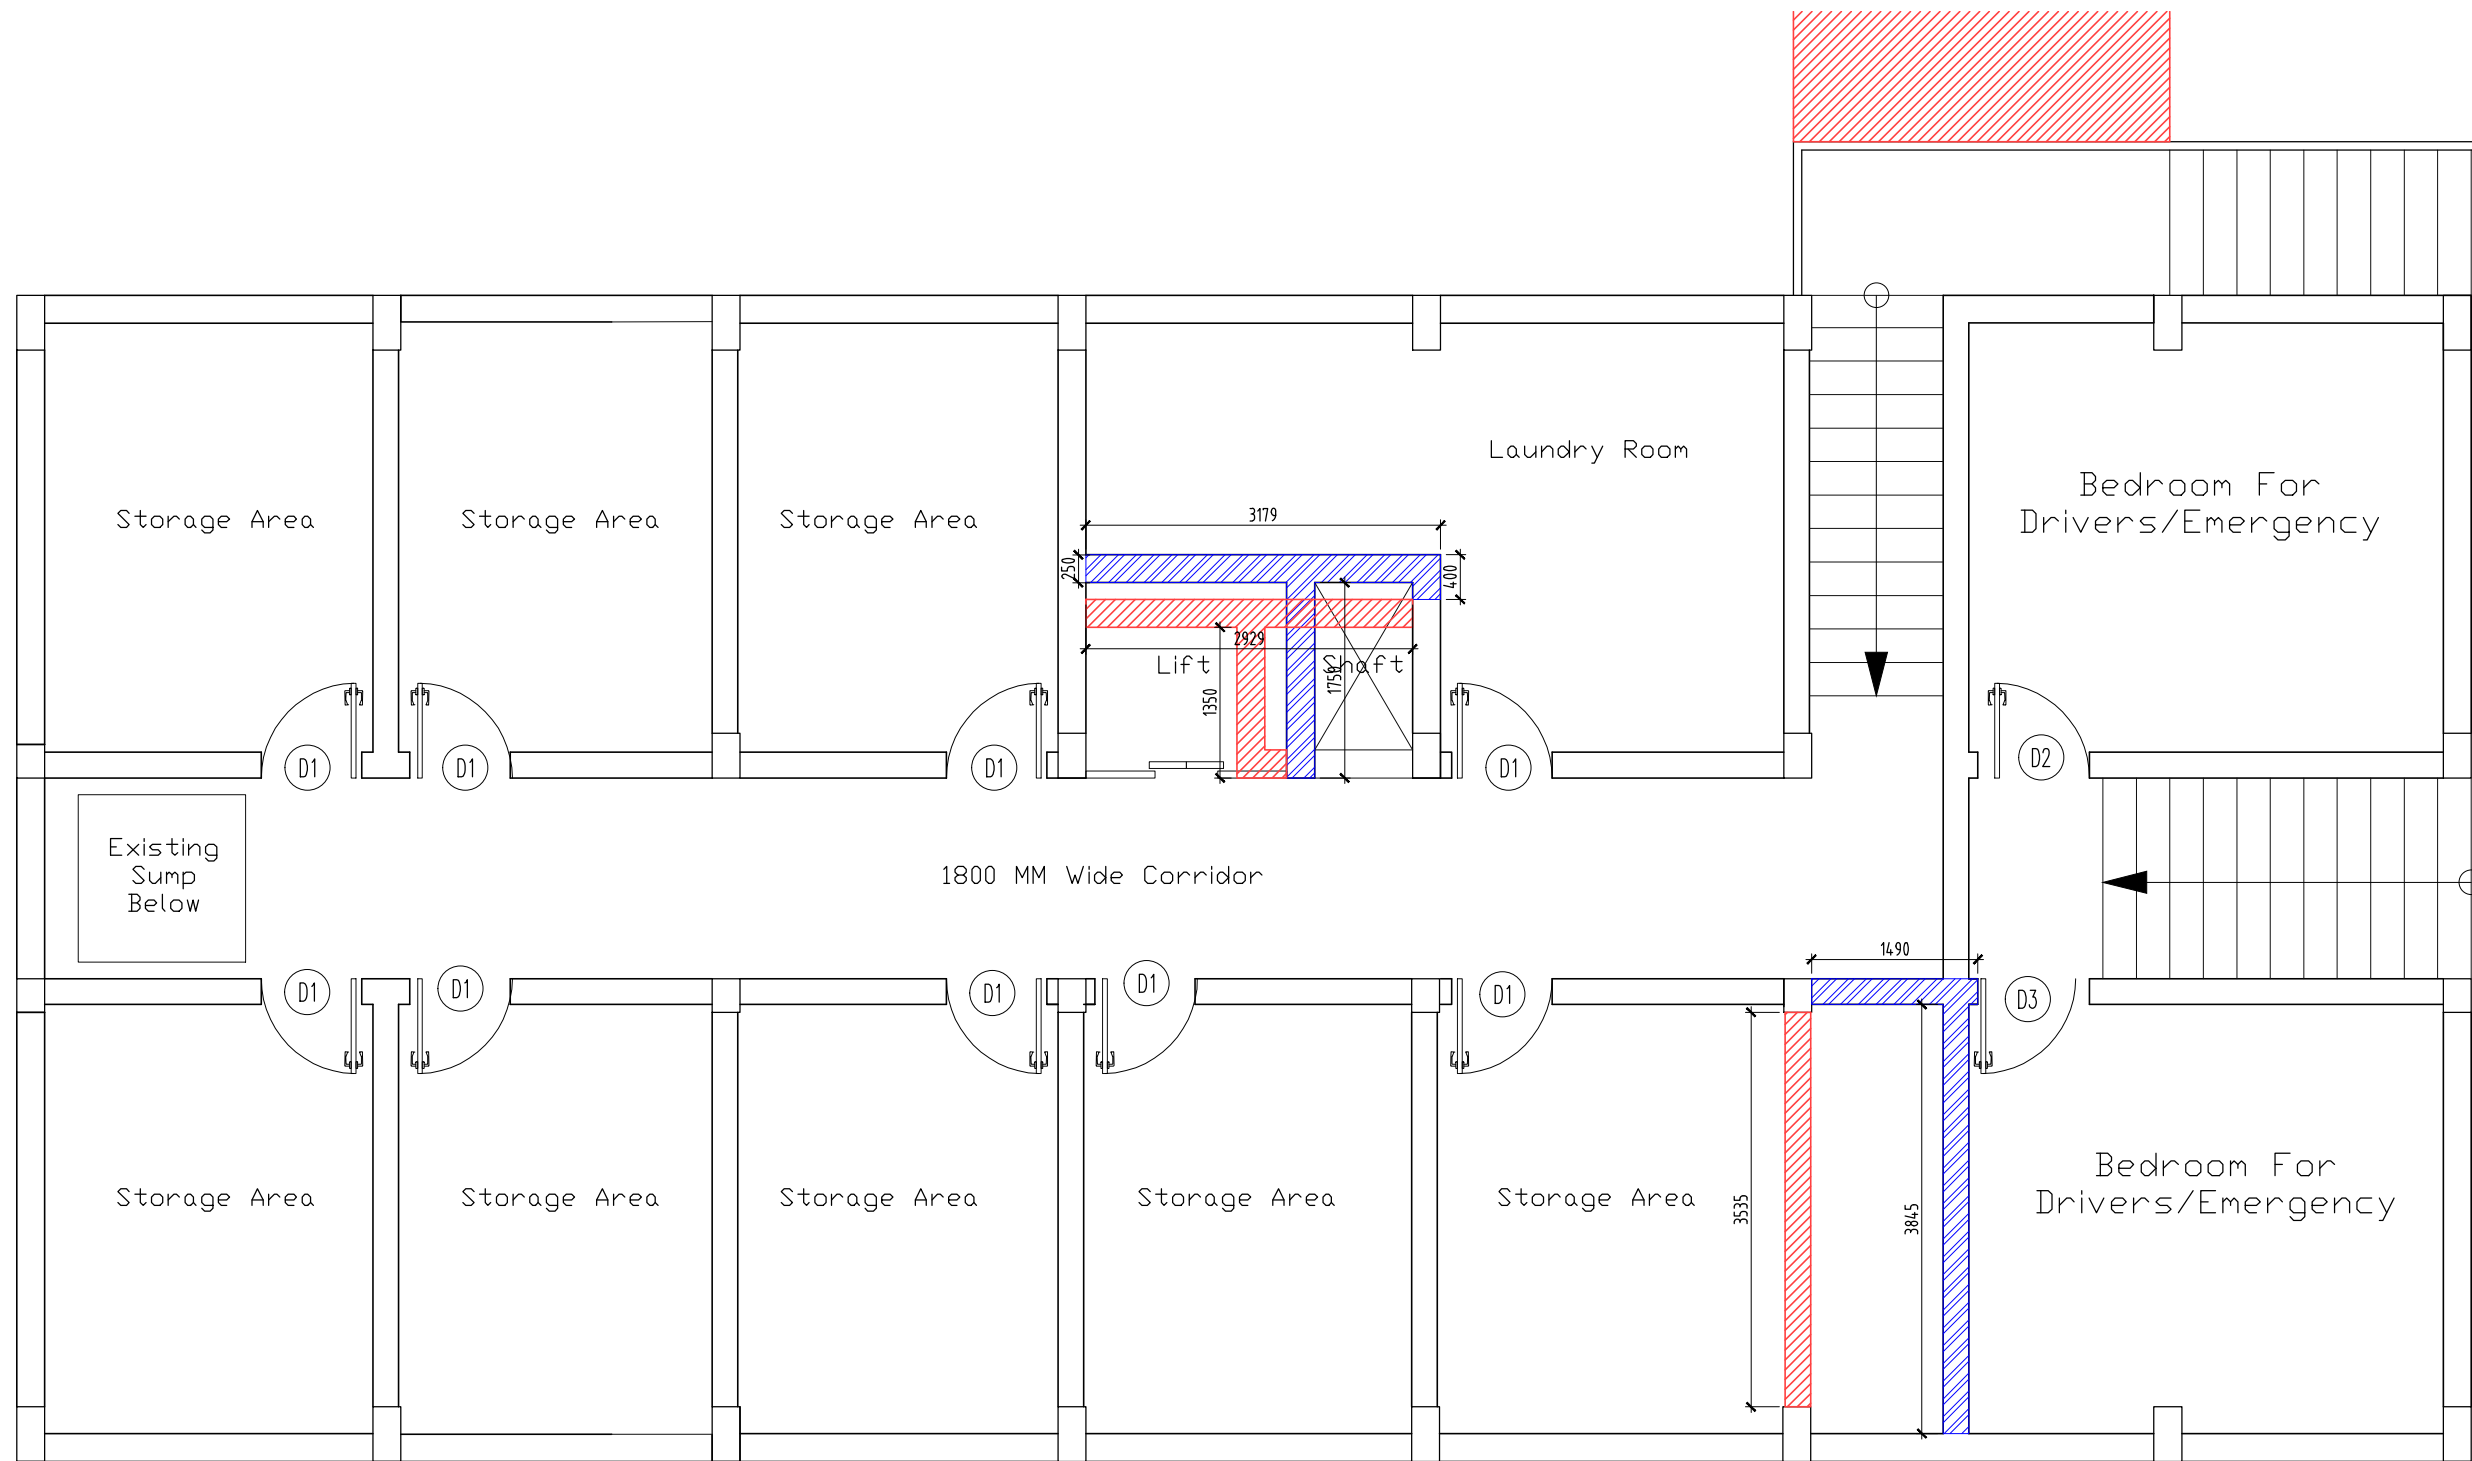

Notes :

1. This drawing is the property and copyright of M/s TAG Builtart. It shall not be copied or used in any way without their written permission.
2. All drawings are in Feet & Inches and to be read only and not measured.
3. Do not scale the dimensions, follow the written dimensions unless otherwise mentioned.
4. Contractors to verify all site conditions and any condition different or not in coherence with the drawings/details must be immediately informed to the Engineers/Architects.

1. DISMANTLING BRICK WORK
2. NEW BRICK WORK

Rev.	Modification	Date	Drawn	Chkd.
RO	For Approval	29-04-2024	ASM	THB

CLIENT:

INDIAN PORT ASSOCIATION

PROJECT TITLE
Guest House
 Lodhi Road, New Delhi
 India

CONSULTANT:
TAG BUILTART
Proficiency and Interior Design Consultants
 Office No. 216 MLU Plot no. 12
 Sector 12 Dwarka, New Delhi-110078
 Mail: info@tagbuiltart.com, Mb: +91 999 919 9201
 Web: www.tagbuiltart.com


MEP CONSULTANT:
 Consulting Engineers Pvt. Ltd.
 H-64, Business Park (Uffim) Sector-63, Noida-201307
 Mail: hvacdesign2010@gmail.com
 Mb No. : +91 971 132 3995
LEOSCOPE

DRAWING TITLE
**Basement
 Rest House
 Construction Plan**

SCALE	DRAWN	APM	DATE	PROJECT NO.
M SHEET:- 1:150	AFM		22-04-2024	170
A3 SHEET:- 1:100	CHECKED	THB		
DRAWING NO.	NORTH		REV.	
IPA-ARC-DWG-AR-1022			0	
CAD FILE REF. BASEMENT				

Notes :

1. This drawing is the property and copyright of M/s TAG BUILTART. It shall not be copied or used in any way without their written permission.
2. All drawings are in Feet & Inches and to be read only and not measured.
3. Do not scale the dimensions, follow the written dimensions unless otherwise mentioned.
4. Contractors to verify all site conditions and any condition different or not in coherence with the drawings/details must be immediately informed to the Engineers/Architects.

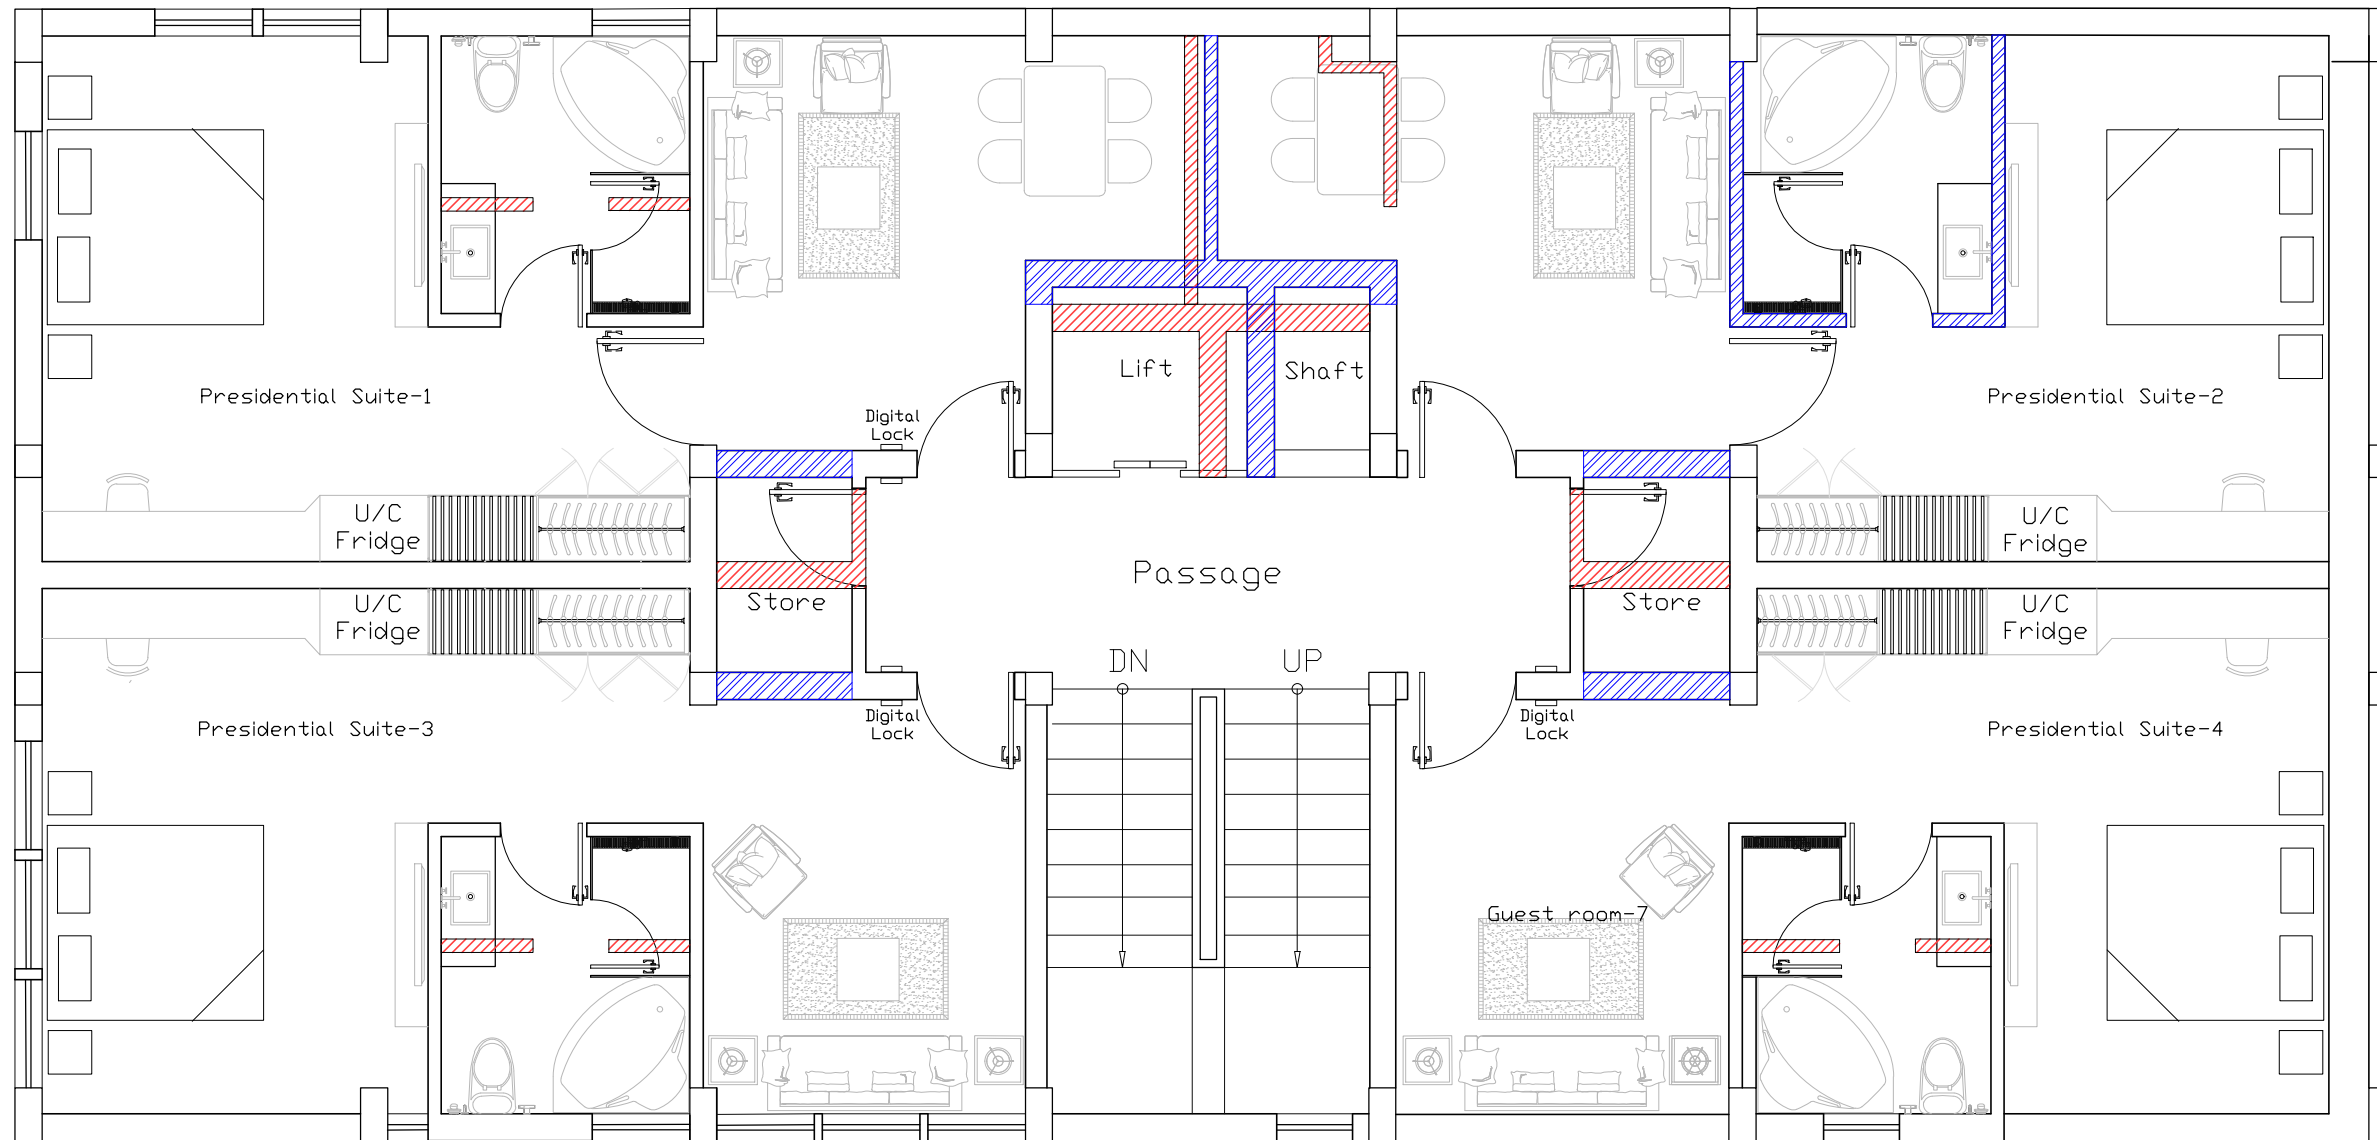

RO	For Approval	22-04-2024	ASM	THB
Rev.	Modification	Date	Drawn	Chkd.

CLIENT:
INDIAN PORT ASSOCIATION


PROJECT TITLE
Guest House
Lodhi Road, New Delhi
India

CONSULTANT:
TAG BUILTART
Architects and Interior Design Consultants
Office No. 216 MLU Plot no. 12
Sector 12 Dwarka, New Delhi-110078
Mail : info@tagbuiltart.com, Mb: +91 999 919 9201
Web: www.tagbuiltart.com

MEP CONSULTANT:
 Consulting Engineers Pvt. Ltd.
H-64, Business Park (Ulfm) Sector-63, Noida-201307
Mail: hvacdesign2010@gmail.com
Mb No. : +91 971 132 3995
LEOSCOPE

DRAWING TITLE
First Floor
Rest House
Construction Plan

SCALE	DRAWN	APM	DATE	PROJECT NO.
M SHEET:- 1:150	CHECKED	THB	22-04-2024	170
A3 SHEET:- 1:100				
DRAWING NO.	NORTH	REV.		
IPA-ARC-DWG-AR-1024		0		
CAD FILE REF. FIRST FLOOR				

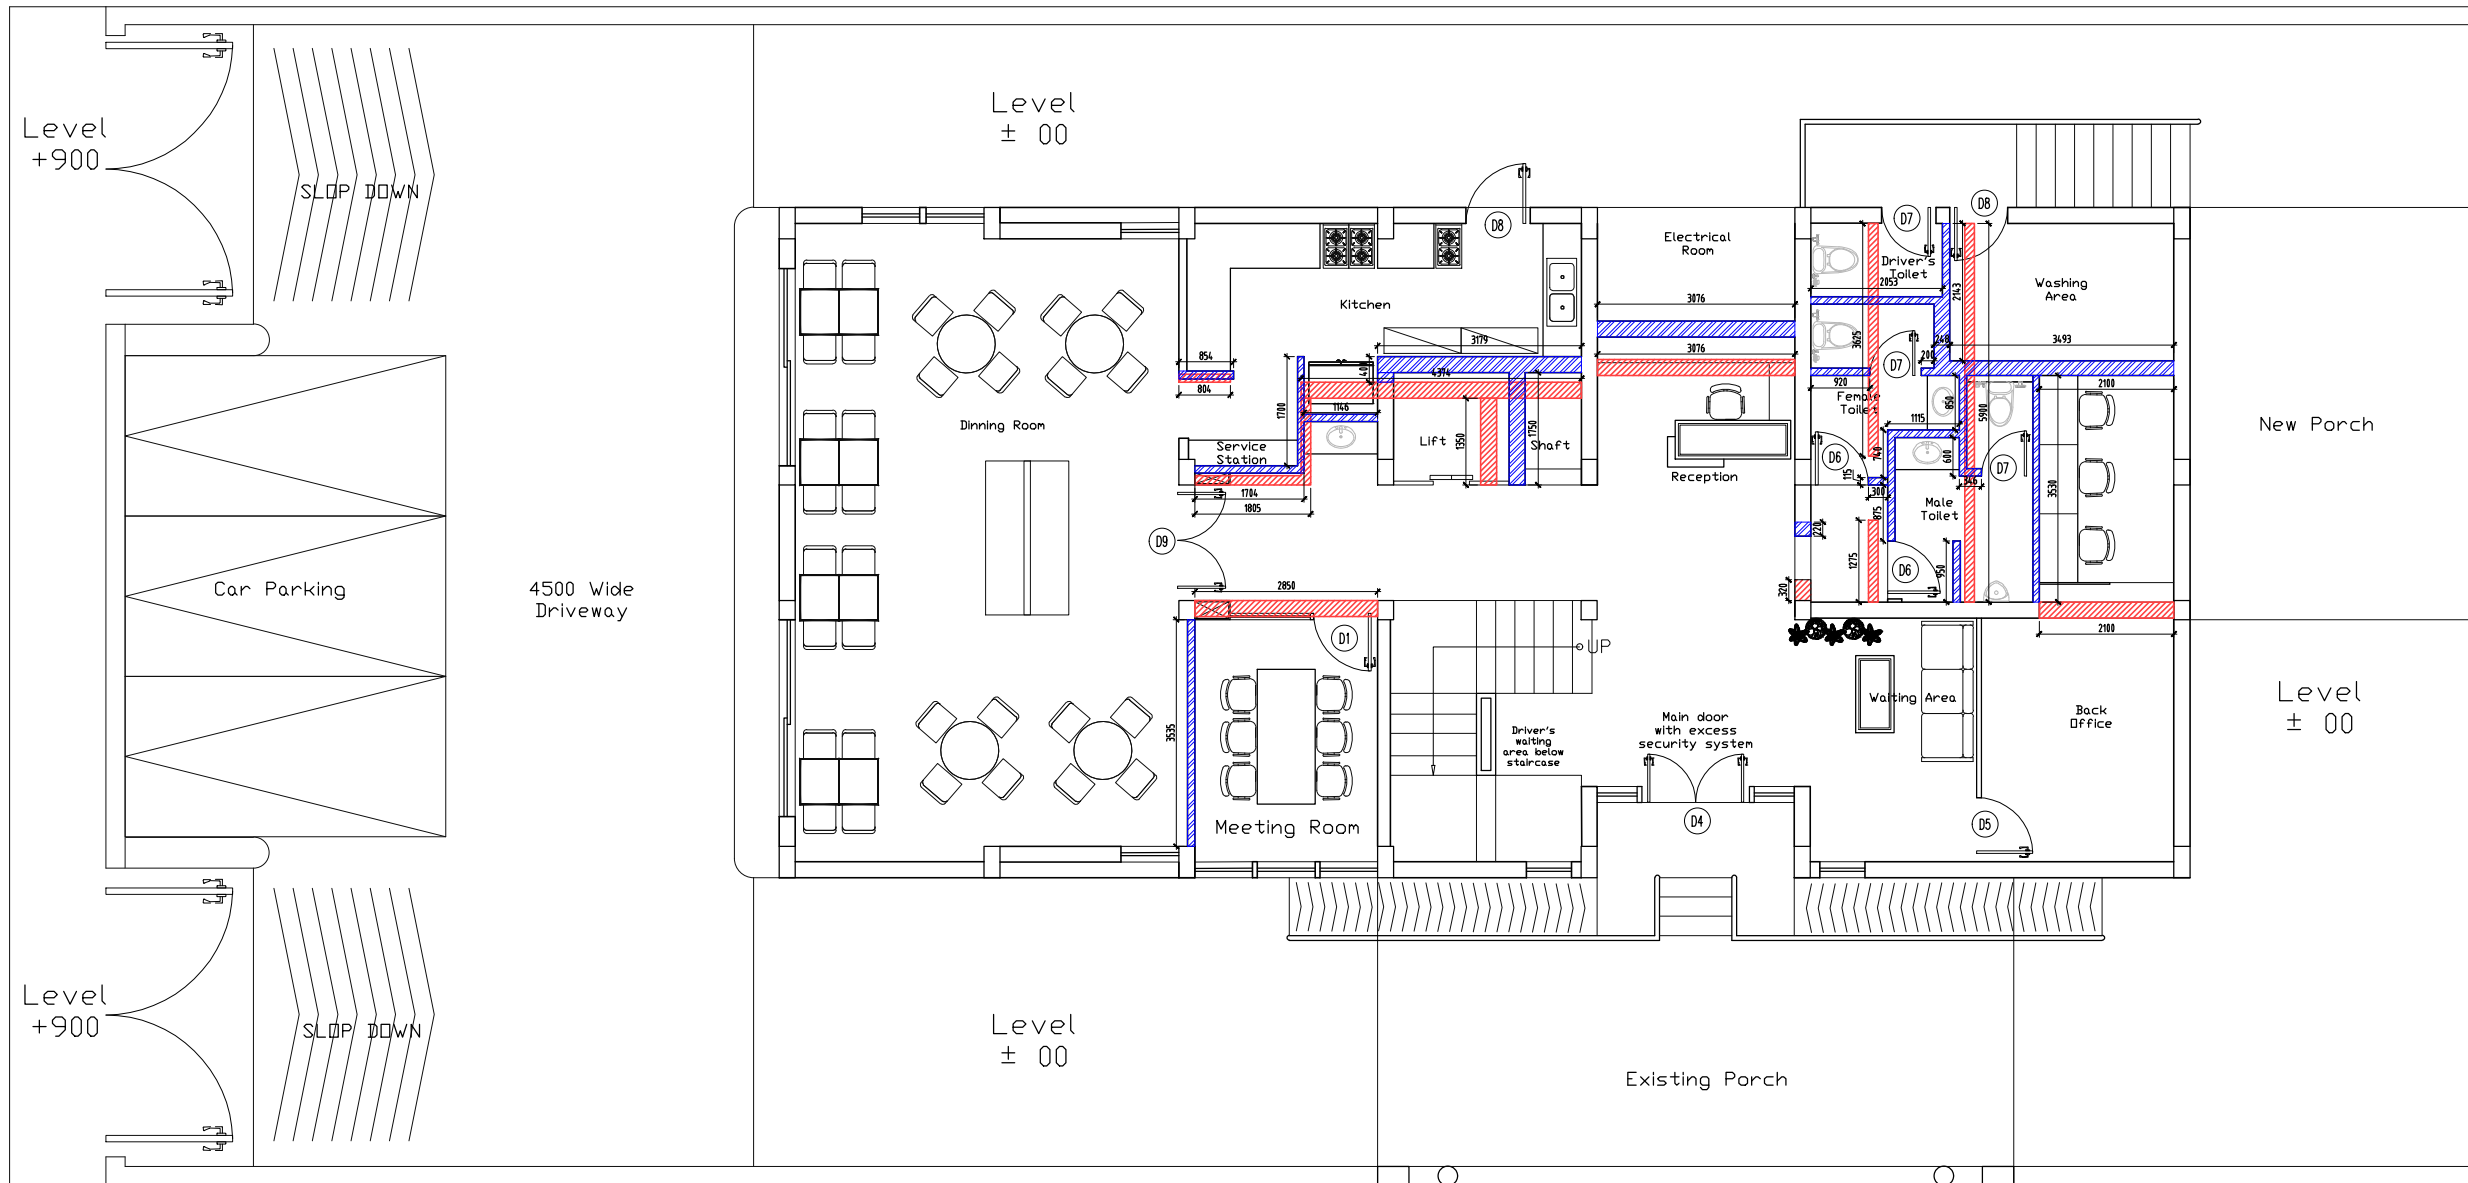

Ground Floor

Notes :

1. This drawing is the property and copyright of M/s TAG BUILTART. It shall not be copied or used in any way without their written permission.
2. All drawings are in Feet & Inches and to be read only and not measured.
3. Do not scale the dimensions, follow the written dimensions unless otherwise mentioned.
4. Contractors to verify all site conditions and any condition different or not in coherence with the drawings/details must be immediately informed to the Engineers/Architects.

1. DISMANTLING BRICK WORK
2. NEW BRICK WORK

Rev.	Modification	Date	Drawn	Chkd.

CLIENT:
INDIAN PORT ASSOCIATION

PROJECT TITLE
Guest House
Lodhi Road, New Delhi
India

CONSULTANT:
TAG BUILTART
Profession and Interior Design Consultants
Office No. 216 MLU Plot no. 12
Sector 12 Dwarka, New Delhi-110078
Mail: info@tagbuiltart.com, Mo: +91 999 919 9201
Web: www.tagbuiltart.com


MEP CONSULTANT:
 Consulting Engineers Pvt. Ltd.
H-64, Business Park (Uffim) Sector-63, Noida-201307
Mail: hvacdesign2010@gmail.com
Mo No. : +91 971 132 3995
LEOSCOPE

DRAWING TITLE
Ground Floor
Rest House
Construction Plan

SCALE	DRAWN	APM	DATE	PROJECT NO.
M SHEET:- 1:150	CHECKED	THB	22-04-2024	170
A3 SHEET:- 1:100				
DRAWING NO.	NORTH	REV.		
IPA-ARC-DWG-AR-1023		0		
CAD FILE REF. GROUND FLOOR				

Notes :

1. This drawing is the property and copyright of M/s TAG BUILTART. It shall not be copied or used in any way without their written permission.
2. All drawings are in Feet & Inches and to be read only and not measured.
3. Do not scale the dimensions, follow the written dimensions unless otherwise mentioned.
4. Contractors to verify all site conditions and any condition different or not in coherence with the drawings/details must be immediately informed to the Engineers/Architects.

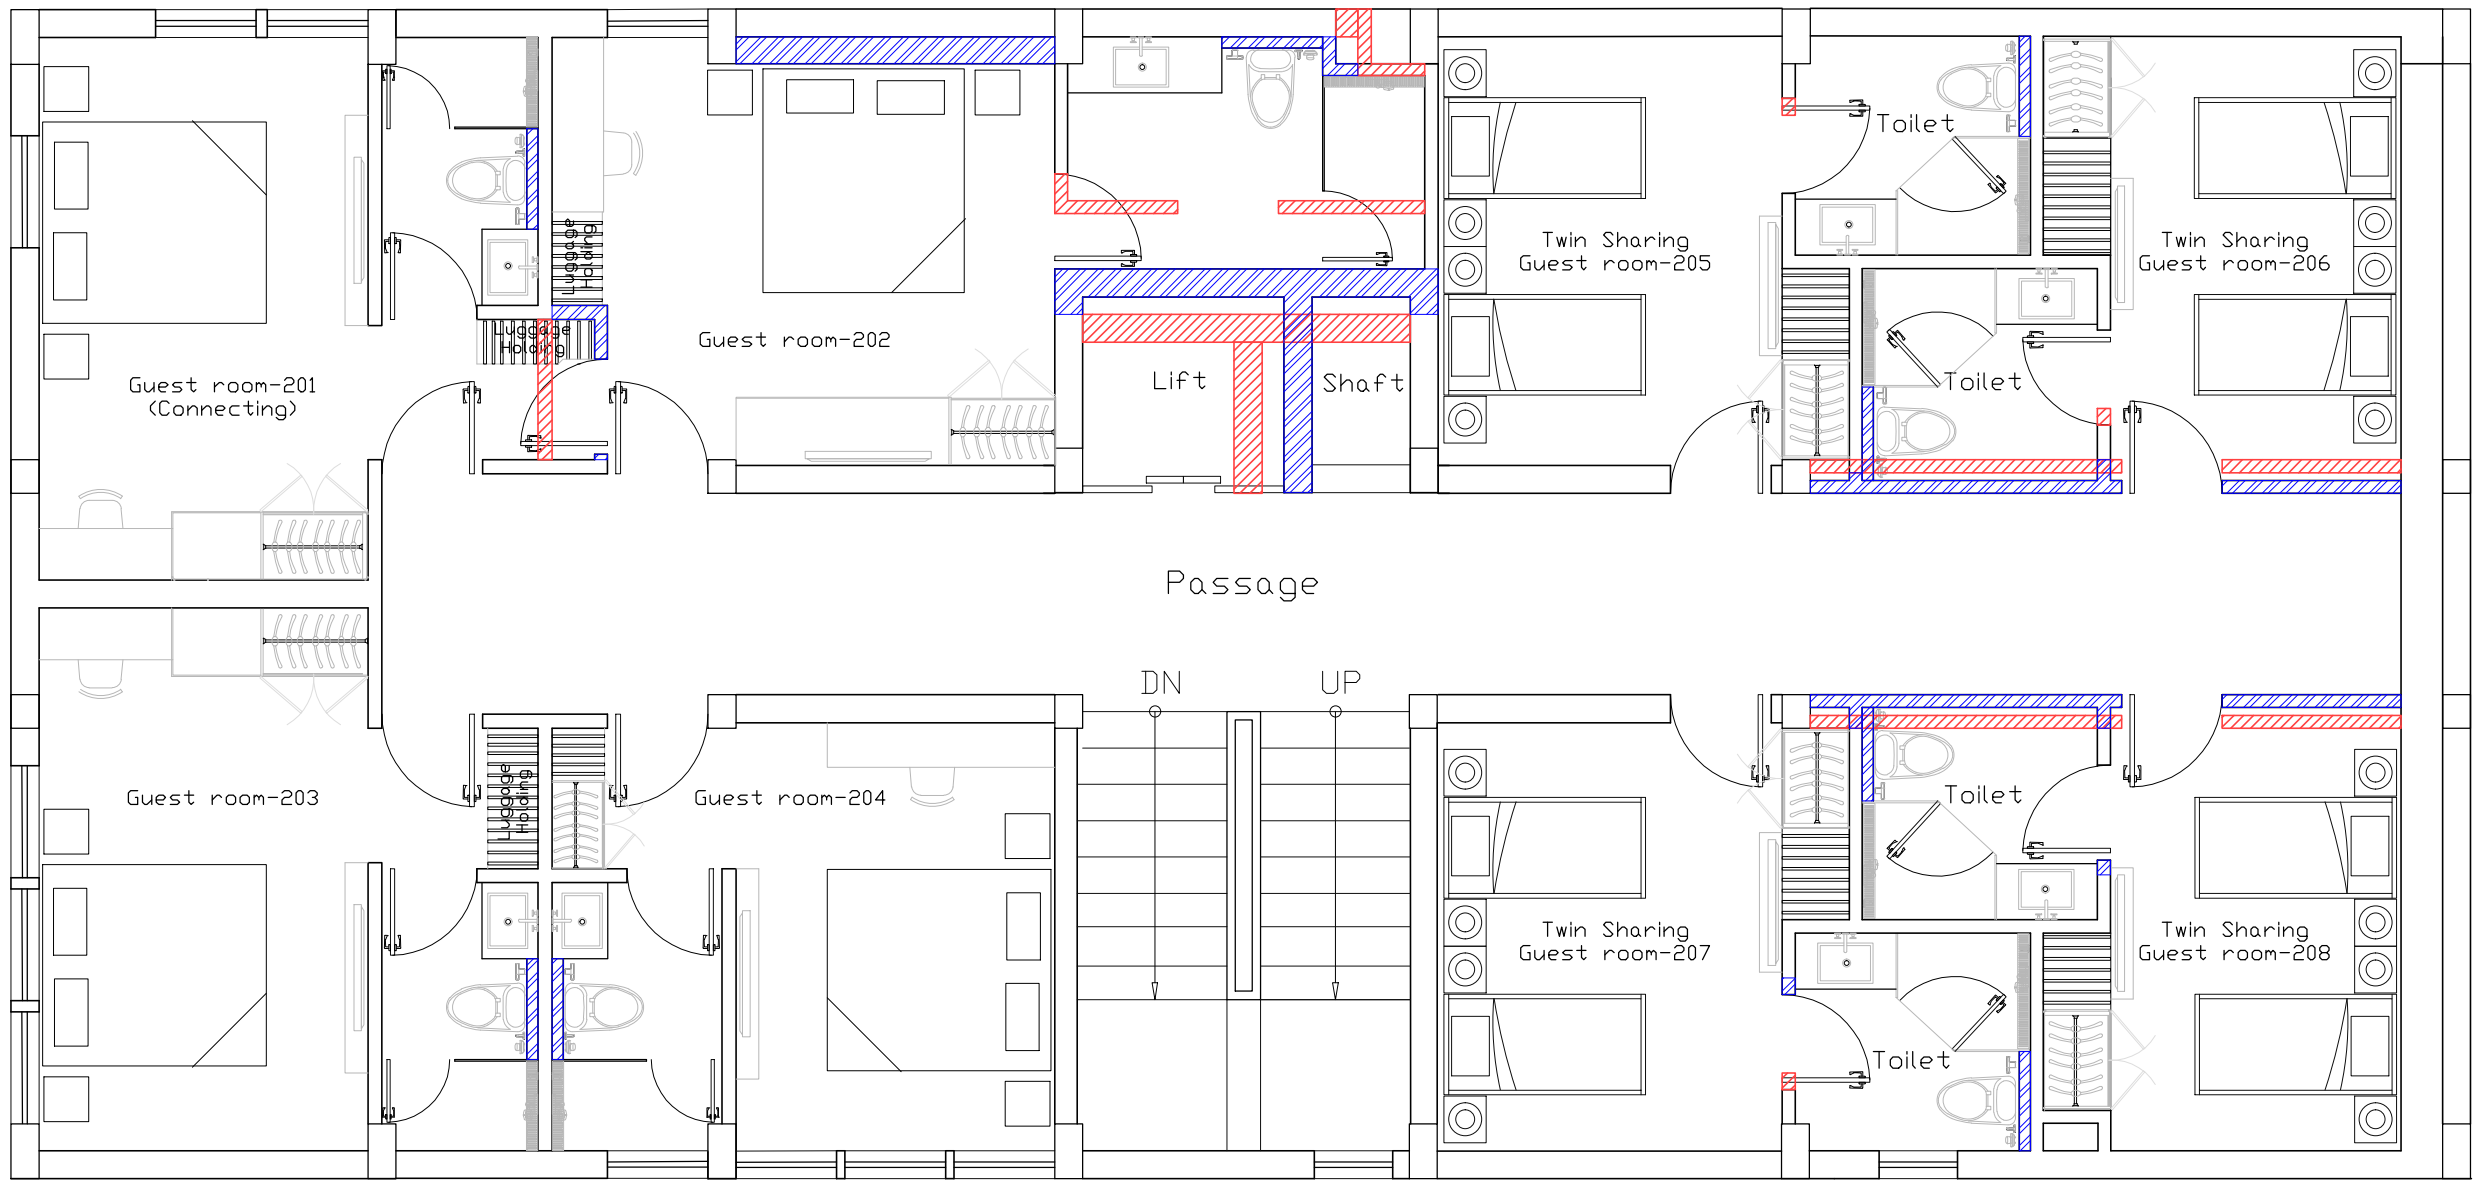

1. DISMANTLING BRICK WORK
2. NEW BRICK WORK

Rev.	Modification	Date	Drawn	Chkd.

CLIENT:
INDIAN PORT ASSOCIATION


PROJECT TITLE
Guest House
Lodhi Road, New Delhi
India

CONSULTANT:
TAG BUILTART
Profession and Interior Design Consultants
Office No. 216 MLU Plot no. 12
Sector 12 Dwarka, New Delhi-110078
Mail: info@tagbuiltart.com, Mb: +91 999 919 9201
Web: www.tagbuiltart.com

MEP CONSULTANT:
 Consulting Engineers Pvt. Ltd.
H-64, Business Park (Uffim) Sector-63, Noida-201307
Mail: hvacdesign2010@gmail.com
Mb No. : +91 971 132 3995
LEOSCOPE

DRAWING TITLE
Second & Third Floor
Rest House
Construction Plan

SCALE	DRAWN	APM	DATE	PROJECT NO.
M SHEET:- 1:150	CHECKED	THB	22-04-2024	170
A3 SHEET:- 1:100				
DRAWING NO.	NORTH	REV.		
IPA-ARC-DWG-AR-1025		0		
CAD FILE REF. SECOND FLOOR				

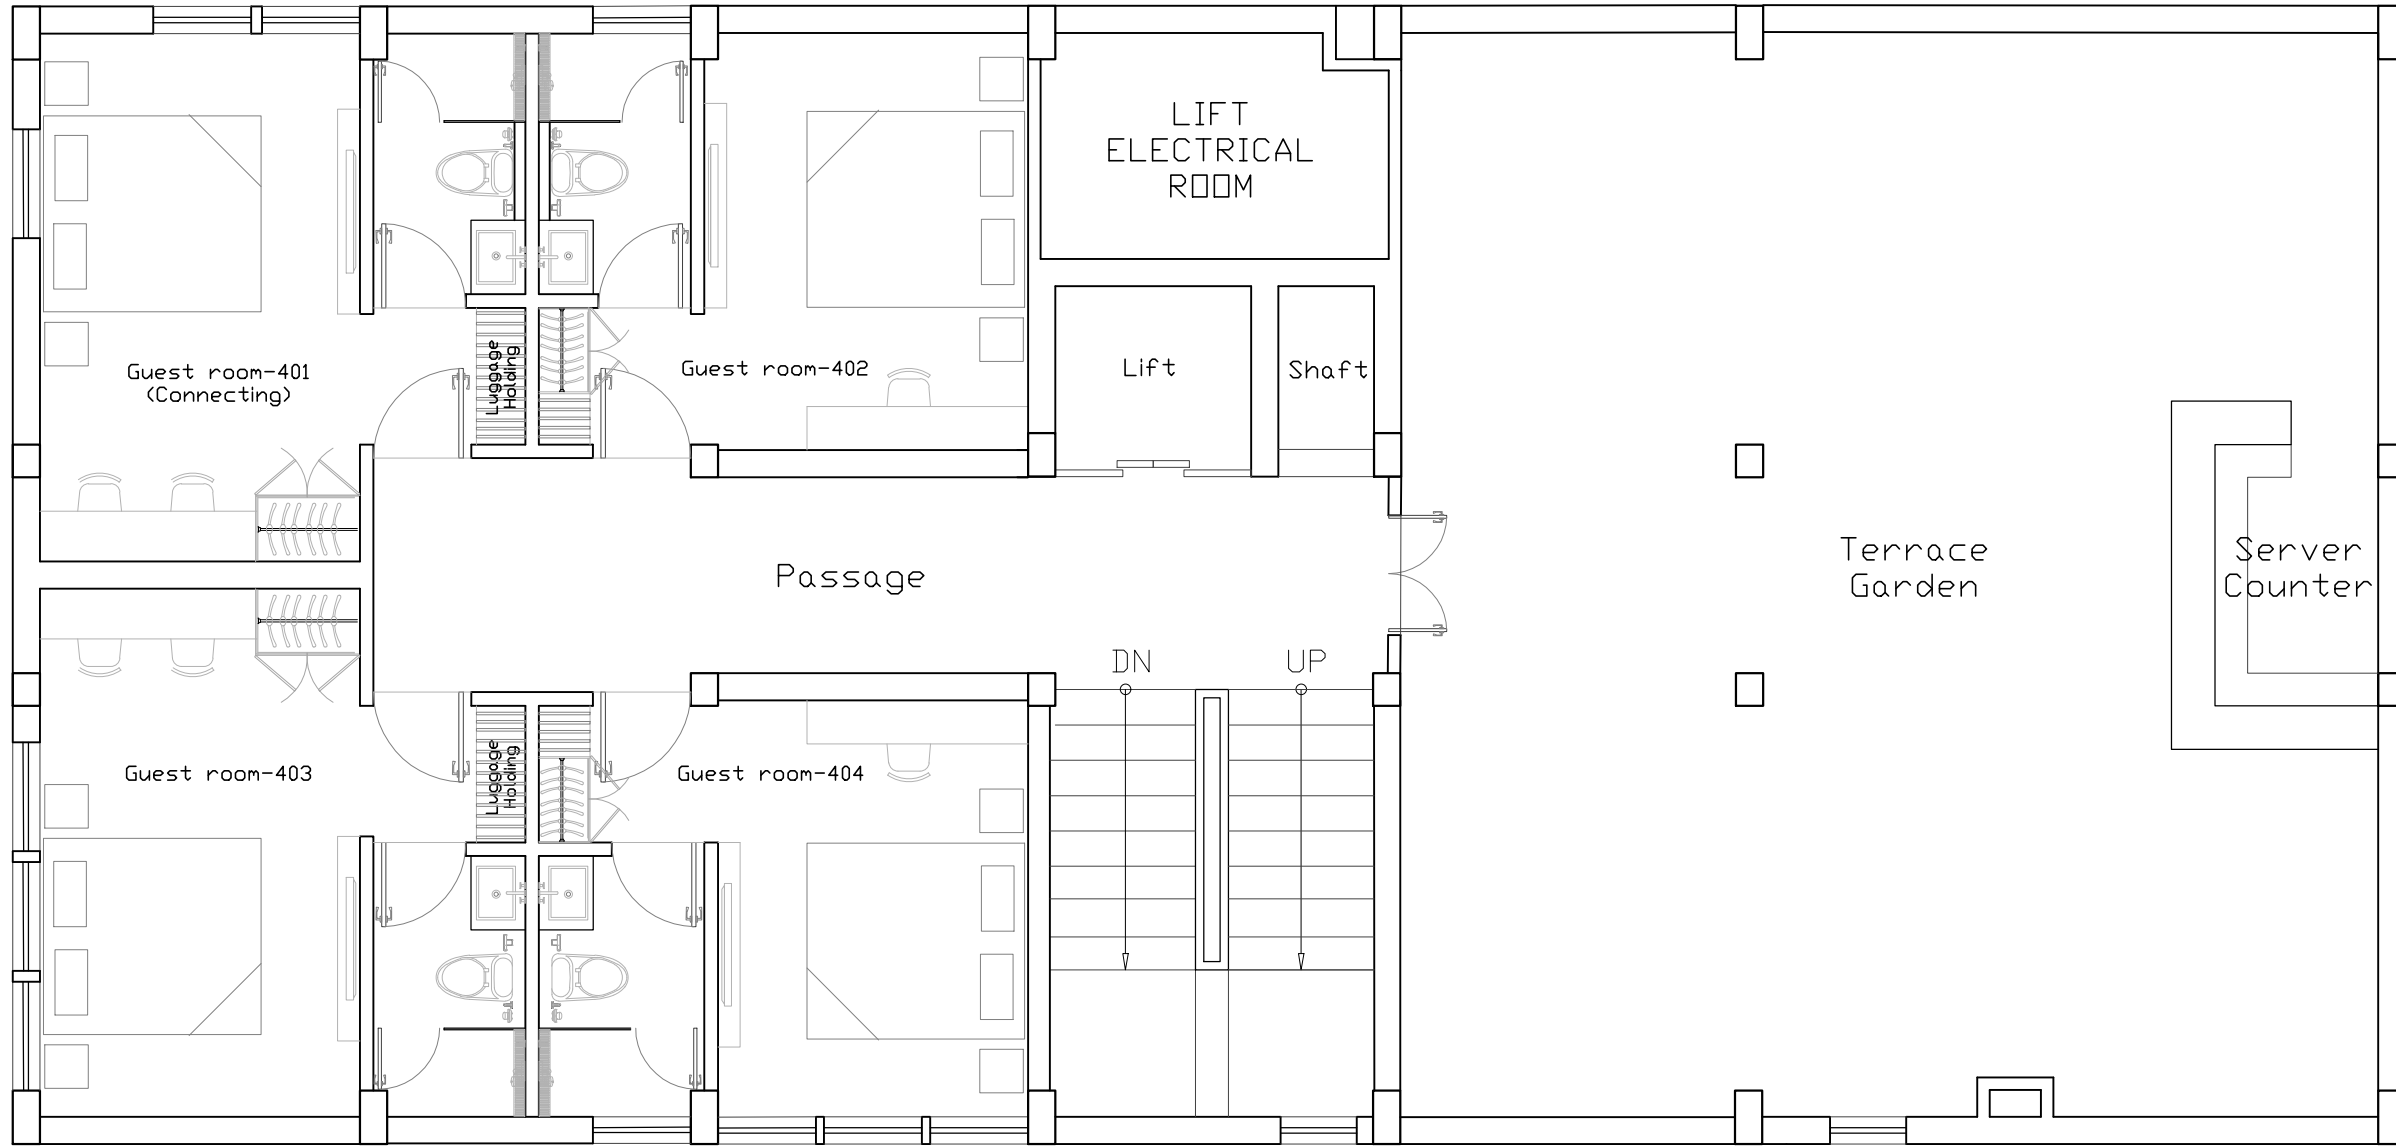

Notes :

1. This drawing is the property and copyright of M/s TAG BUILTART. It shall not be copied or used in any way without their written permission.
2. All drawings are in Feet & Inches and to be read only and not measured.
3. Do not scale the dimensions, follow the written dimensions unless otherwise mentioned.
4. Contractors to verify all site conditions and any condition different or not in coherence with the drawings/details must be immediately informed to the Engineers/Architects.

Rev.	Modification	Date	Drawn	Chkd.
RO	For Approval	29-04-2024	ASM	THB

CLIENT:

INDIAN PORT ASSOCIATION

PROJECT TITLE
Guest House
 Lodhi Road, New Delhi
 India

CONSULTANT:
TAG BUILTART
Proficiency and Interior Design Consultants
 Office No. 216 MLU Plot no. 12
 Sector 12 Dwarka, New Delhi-110078
 Mail: info@tagbuiltart.com, Mb: +91 999 919 9201
 Web: www.tagbuiltart.com


MEP CONSULTANT:
 Consulting Engineers Pvt. Ltd.
 H-64, Business Park (Uffim) Sector-63, Noida-201307
 Mail: hvacdesign2010@gmail.com
 Mb No. : +91 971 132 3995
 LEOSCOPE

DRAWING TITLE
Fourth Floor
Rest House
Construction


SCALE	DRAWN	APM	DATE	PROJECT NO.
M SHEET:- 1:150	CHECKED	THB	22-04-2024	170
A3 SHEET:- 1:100				
DRAWING NO.	NORTH		REV.	
IPA-ARC-DWG-AR-1027				0
CAD FILE REF.FOURTH FLOOR				

Notes :


1. This drawing is the property and copyright of M/s TAG BUILTART. It shall not be copied or used in any way without their written permission.
2. All drawings are in Feet & Inches and to be read only and not measured.
3. Do not scale the dimensions, follow the written dimensions unless otherwise mentioned.
4. Contractors to verify all site conditions and any condition different or not in coherence with the drawings/details must be immediately informed to the Engineers/Architects.

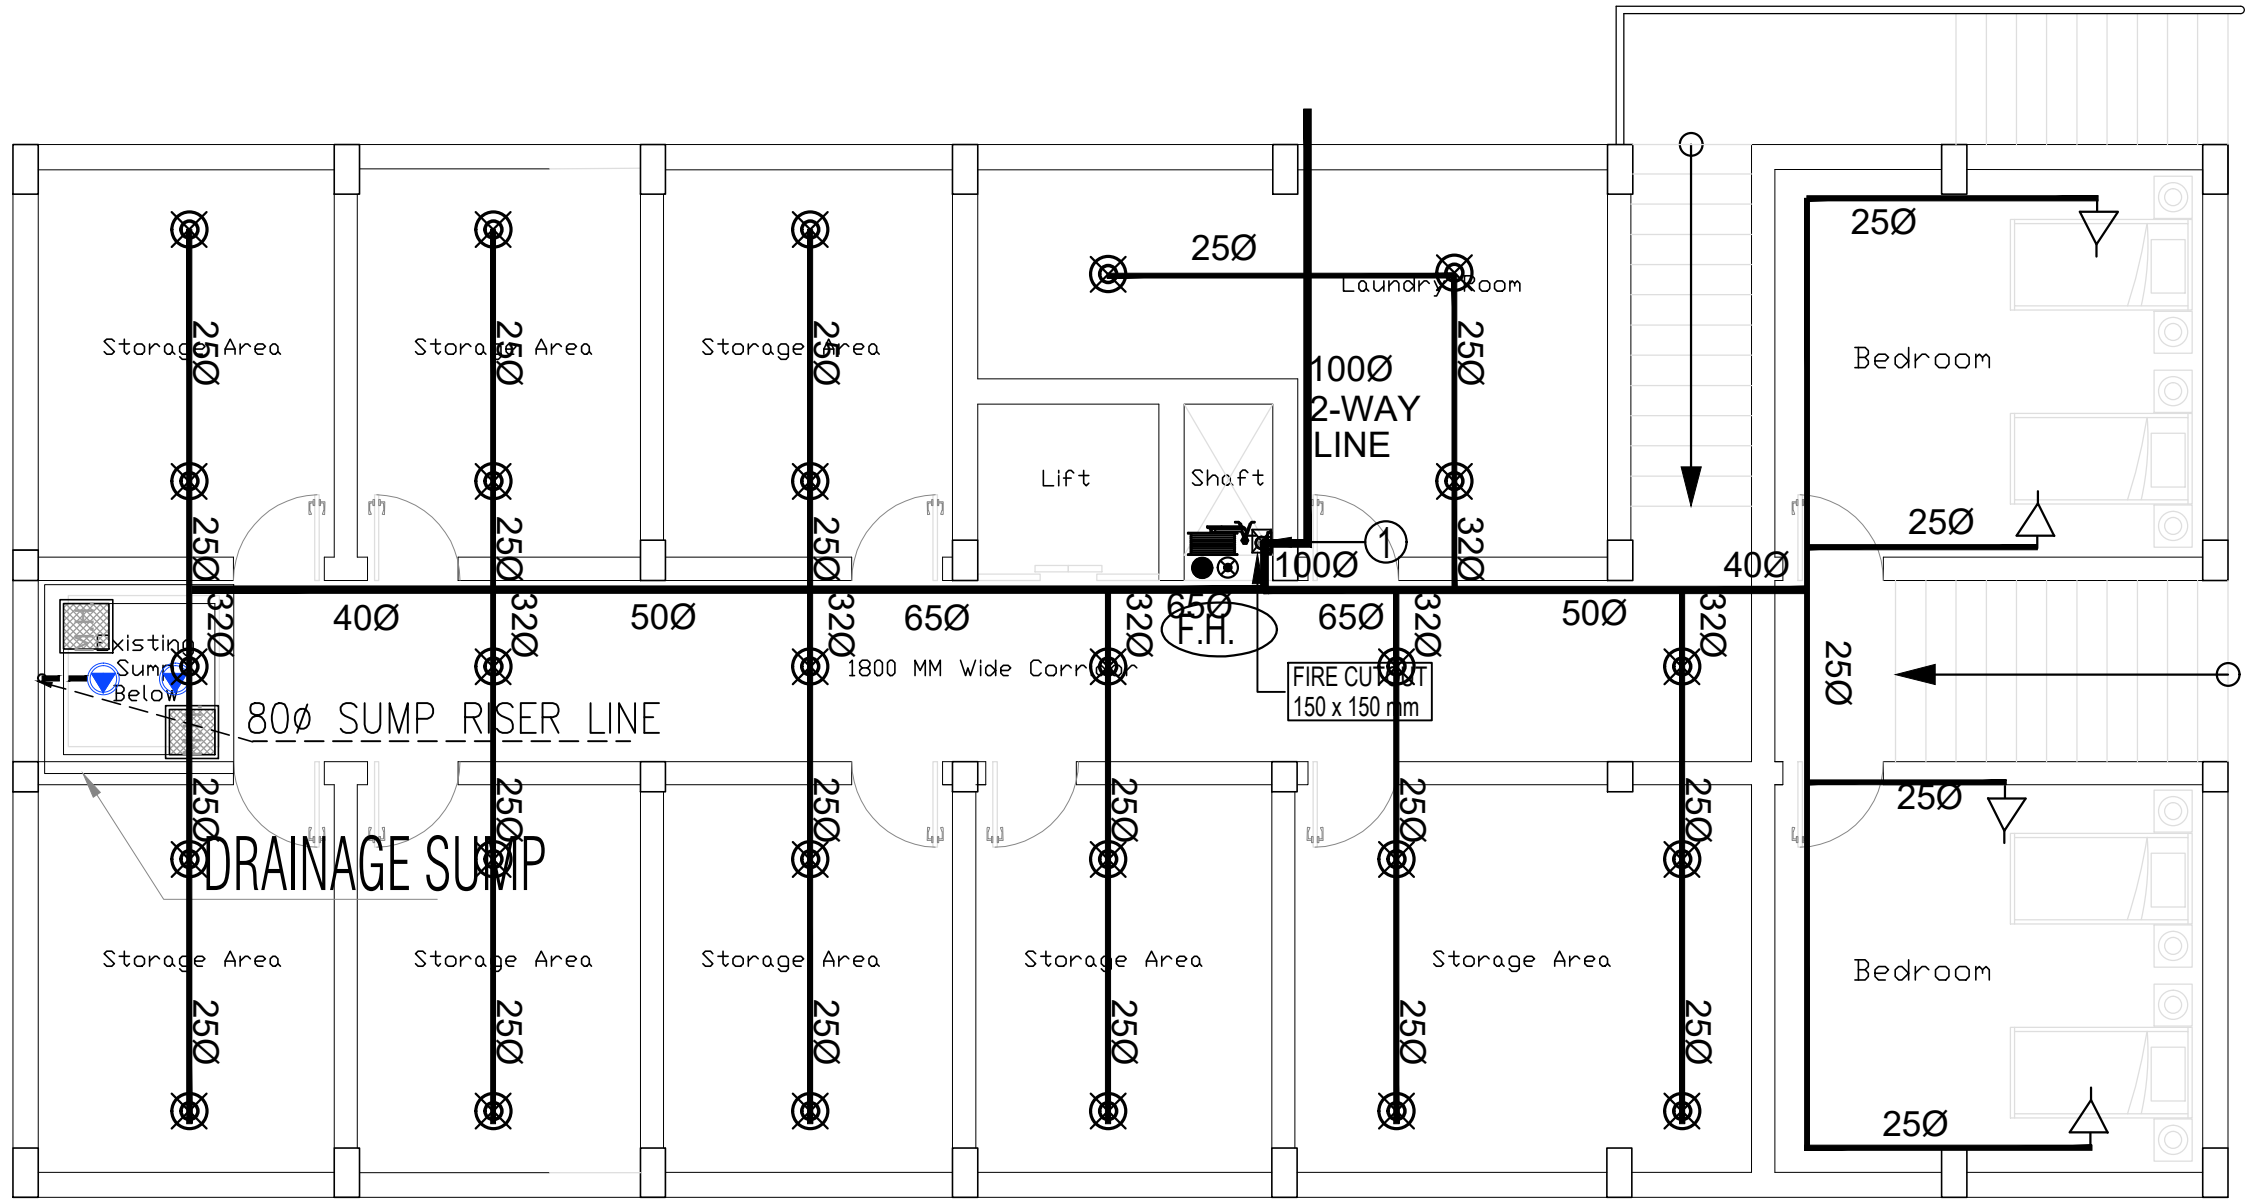

1. PENDENT SPRINKLER	
2. SIDEWALL SPRINKLER	
3. 100Ø RISER PIPE	

RO	Tender Docket	22-04-2024	ASM	THB
Rev.	Modification	Date	Drawn	Chkd.
CLIENT: M/s INDIAN PORT ASSOCIATION				
PROJECT TITLE: Rest House Lodhi Road, New Delhi India				
CONSULTANT: TAG BUILTART Architects and Interior Design Consultants Office No. 322, III Floor Aggarwal Square Plaza, Plot no. 9, Pocket 7, Sector 12 Dwarka, New Delhi-110078 Mail: info@tagbuiltart.com, Mo: +91 999 919 9201 Web: www.tagbuiltart.com				
MEP CONSULTANT:  Consulting Engineers Pvt. Ltd. H-64, Business Park (Uffim) Sector-63, Noida-201307 Mail: hvacdesign2010@gmail.com Mo No. : +91 971 132 3995				
LEOSCOPE				
DRAWING TITLE: Basement Plumbing and Fire Fighting Tender Docket				
SCALE	DRAWN	APM	DATE	PROJECT NO.
M SHEET:- 1:150	CHECKED	THB	22-04-2024	170
A3 SHEET:- 1:100				
DRAWING NO.	NORTH		REV.	
IPA-ARC-DWG-AR-1431			0	
CAD FILE REF: PLUMBING & FIRE				

- Notes :
1. This drawing is the property and copyright of M/s TAG BUILTART. It shall not be copied or used in any way without their written permission.
 2. All drawings are in Feet & Inches and to be read only and not measured.
 3. Do not scale the dimensions, follow the written dimensions unless otherwise mentioned.
 4. Contractors to verify all site conditions and any condition different or not in coherence with the drawings/details must be immediately informed to the Engineers/Architects.

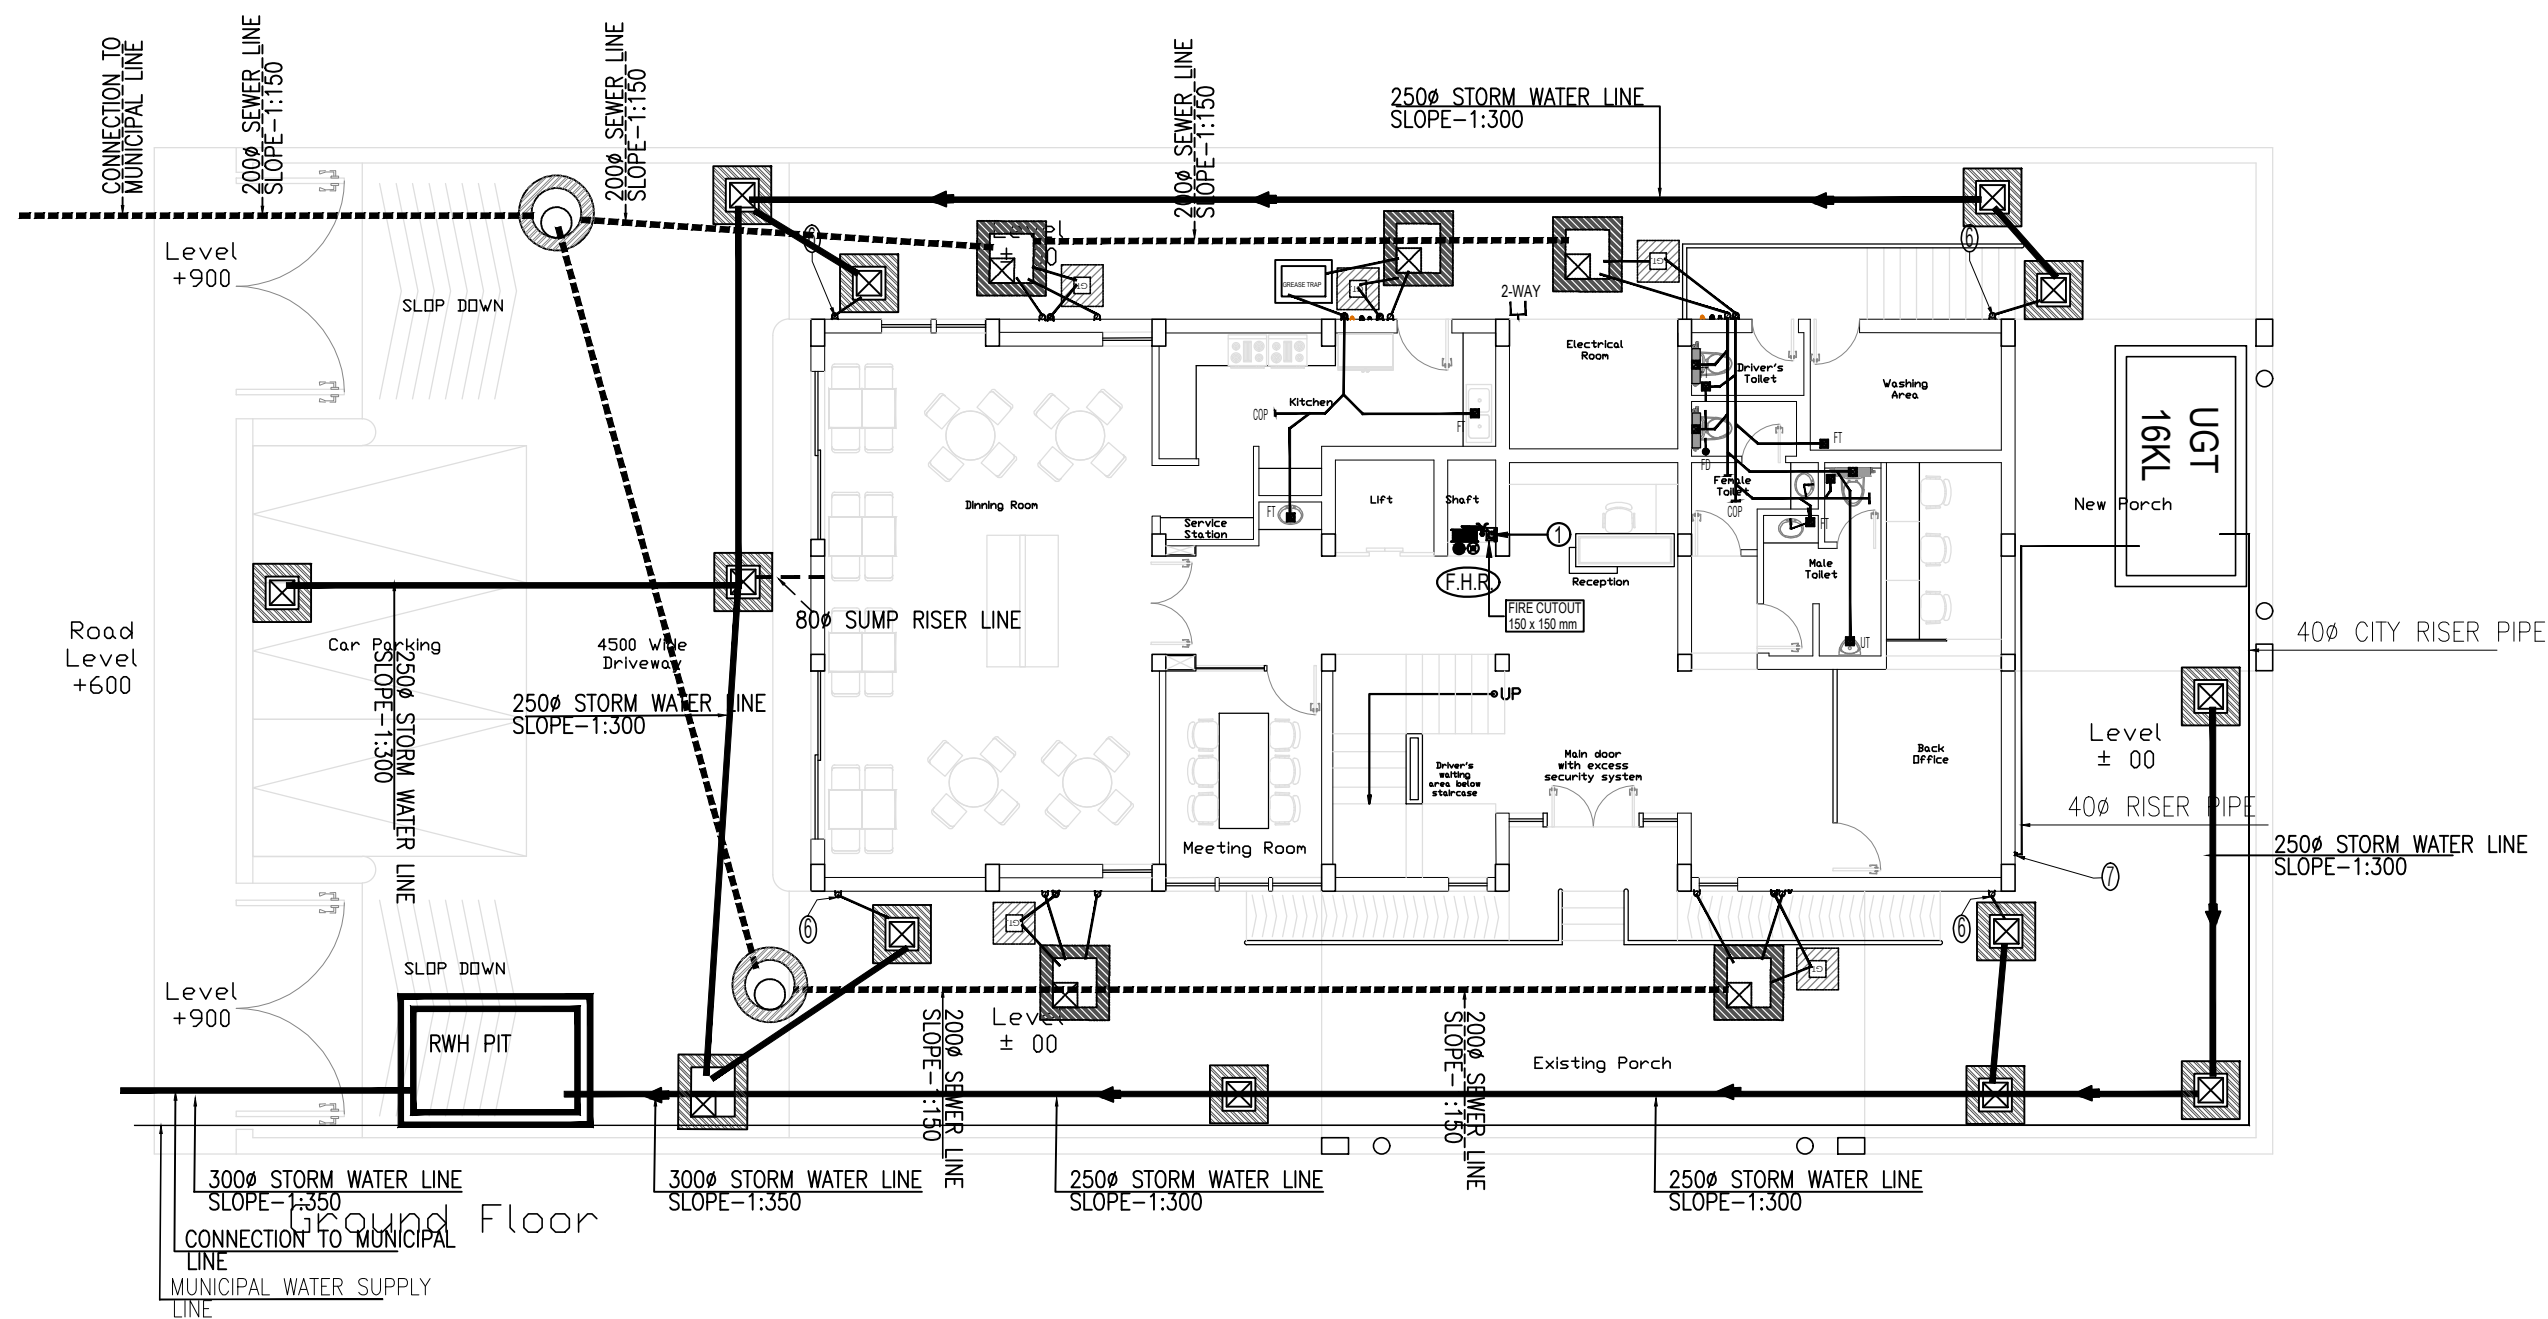

PLUMBING NOTE FOR STROM WATER :-

MANHOLE SIZE (MM)	DEPTH OF MH (MM)
CB - 450 X 450 mm	450mm - 775 mm
MH - 800 X 900 mm	750mm TO 900 mm
910mm Dia	900 TO 1650

PLUMBING LEGEND:-

	SEWER WATER MANHOLE
	STORM WATER MANHOLE
	RAIN WATER HARVESTING PIT
	SEWER LINE
	STROM LINE
	DOMESTIC WATER SUPPLY

Rev.	Modification	Date	Drawn	Chkd.
RD	Tender Docket	21-04-2024	ASM	THB

CLIENT:
M/s INDIAN PORT ASSOCIATION

PROJECT TITLE
Rest House
Lodhi Road, New Delhi
India


CONSULTANT:
TAG BUILTART
Architects and Interior Design Consultants
Office No. 322, III Floor Aggarwal Square Plaza, Plot no. 9,
Pocket 7, Sector 12 Dwarka, New Delhi-110078
Mail : info@tagbuiltart.com, Mb: +91 999 919 9201
Web: www.tagbuiltart.com

MEP CONSULTANT:
 Consulting Engineers Pvt. Ltd.
H-64, Business Park (Ulfm) Sector-63, Noida-201307
Mail: hvacdesign2010@gmail.com
Mb No. : +91 971 132 3995

DRAWING TITLE
Ground Floor
Plumbing and Fire Fighting
Tender Docket

SCALE	DRAWN	APM	DATE	PROJECT NO.
M SHEET:- 1:150			22-04-2024	170
A3 SHEET:- 1:100	CHECKED	THB		
DRAWING NO.		NORTH	REV.	
IPA-ARC-DWG-AR-1432			0	
CAD FILE REF. PLUMBING & FIRE				

- Notes :
1. This drawing is the property and copyright of M/s TAG BUILTART. It shall not be copied or used in any way without their written permission.
 2. All drawings are in Feet & Inches and to be read only and not measured.
 3. Do not scale the dimensions, follow the written dimensions unless otherwise mentioned.
 4. Contractors to verify all site conditions and any condition different or not in coherence with the drawings/details must be immediately informed to the Engineers/Architects.

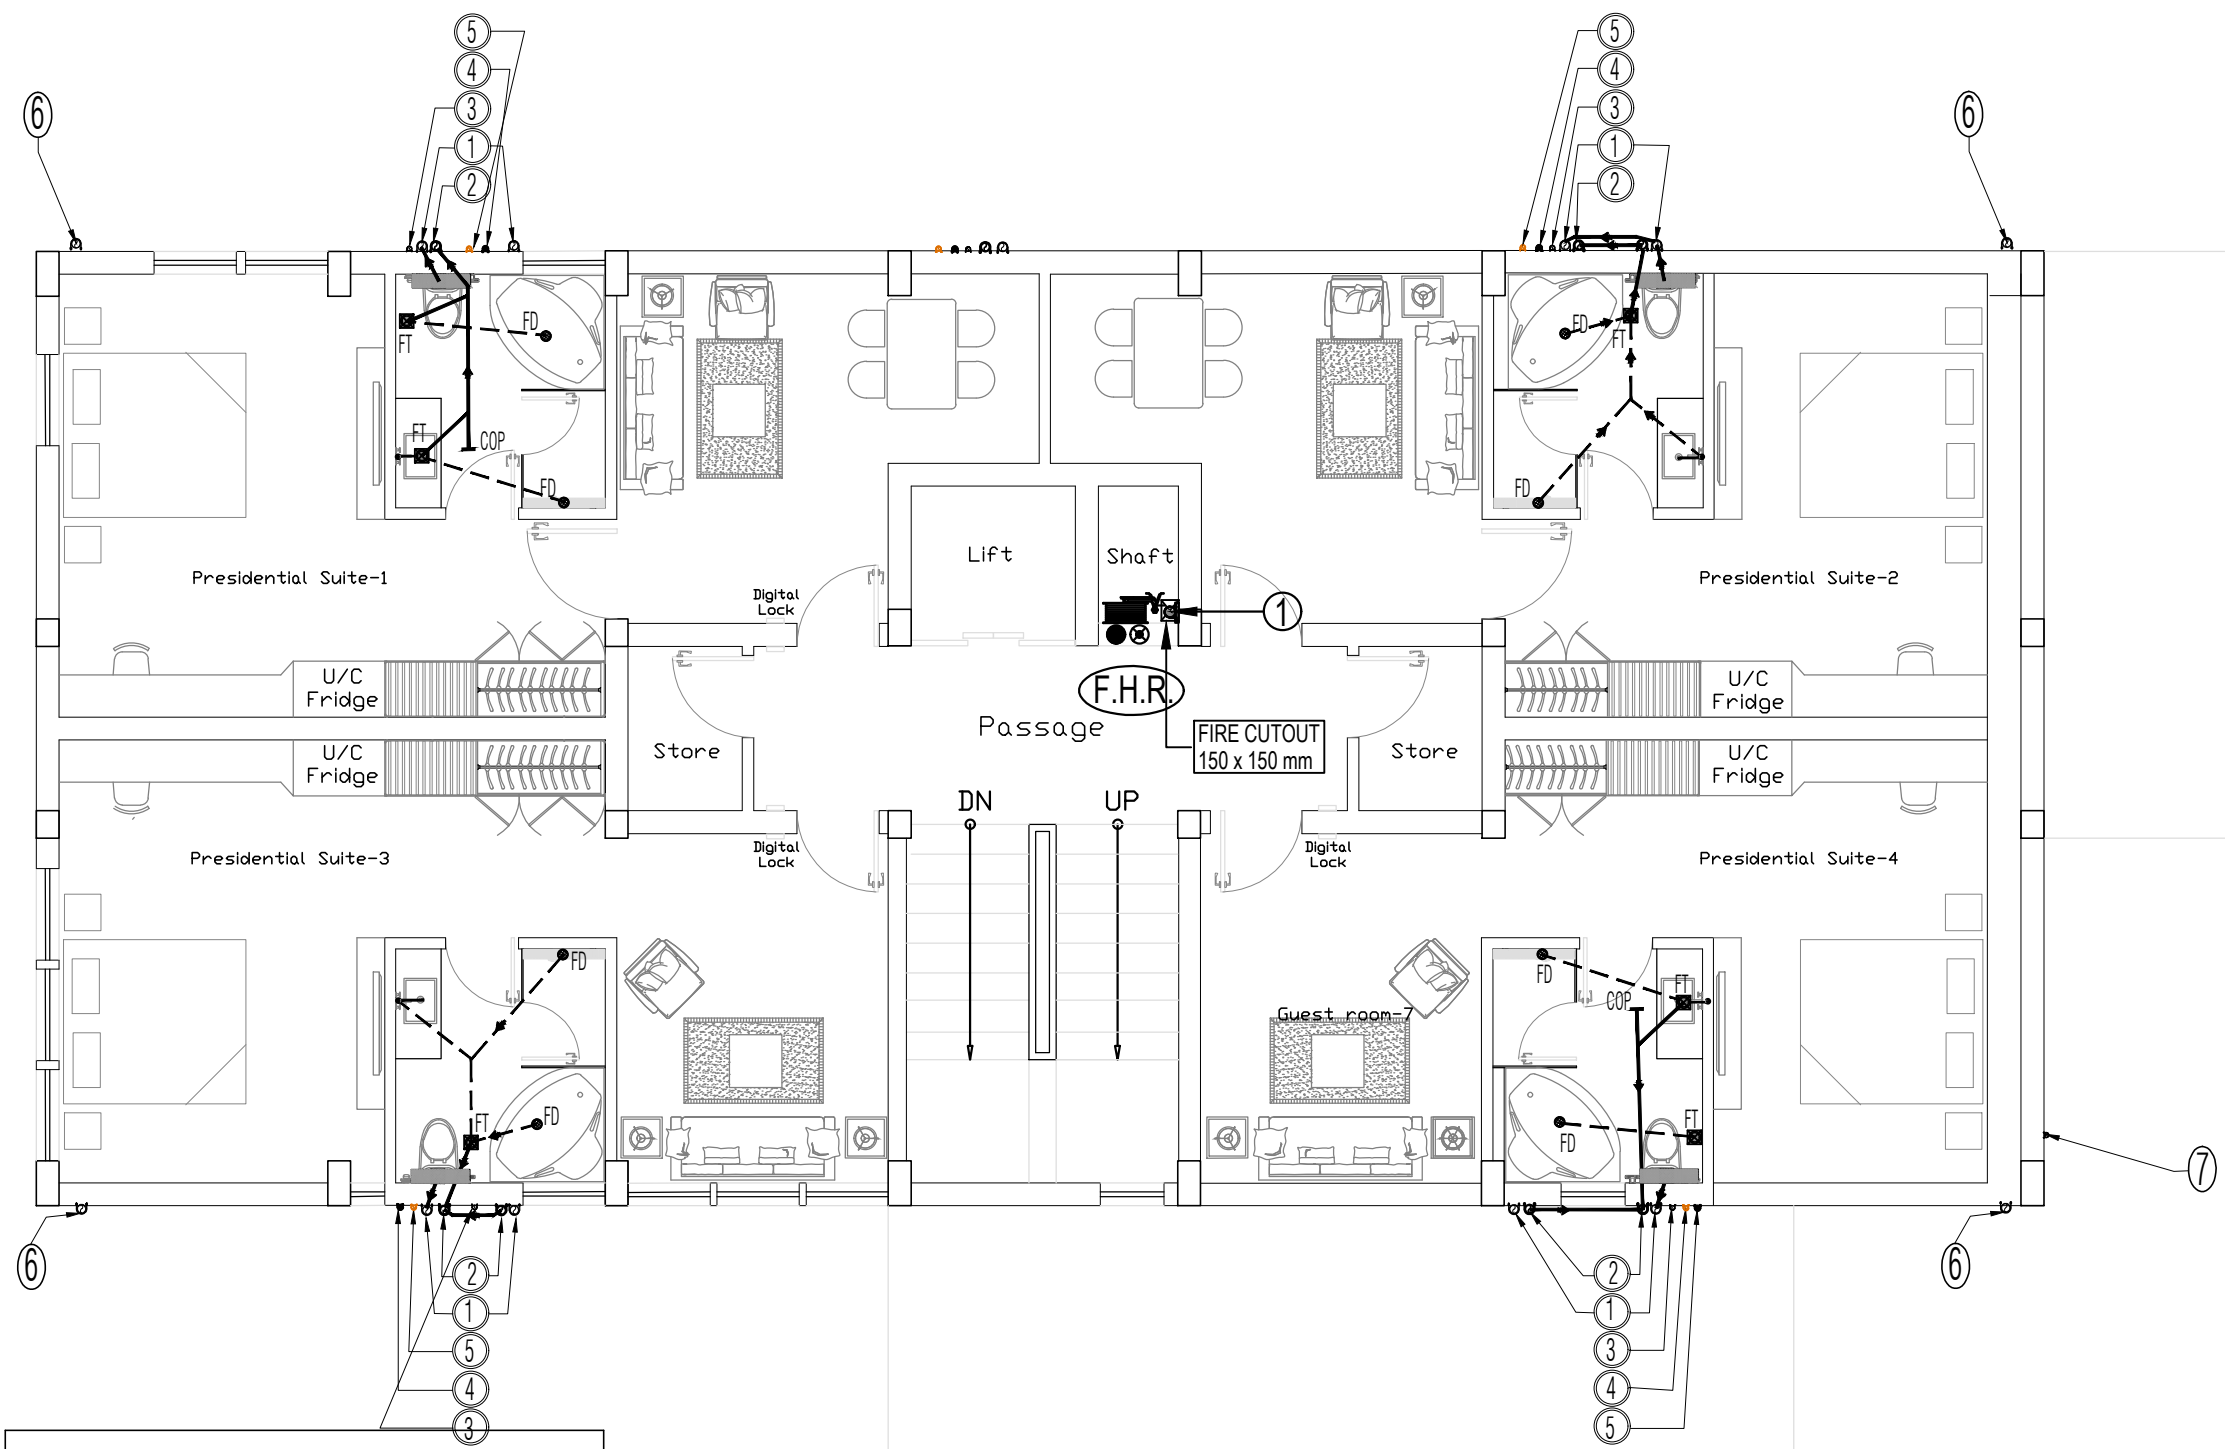

1.	WASH BASIN TO FLOOR TRAP (FT) 40 OD uPVC WASTE PIPE
2.	MULTI TRAP TO FLOOR TRAP 50 OD upvc WASTE PIPE
3.	KITCHEN SINK TO FLOOR TRAP (FT) 50 OD upvc WASTE PIPE
4.	110 OD uPVC SWR TYPE-B PIPE USED FOR SOIL & WASTE LINE.
5.	110 OD uPVC SWR TYPE-B PIPE USED FOR KITCHEN WASTE LINE.
6.	110 OD uPVC SWR TYPE-A PIPE USED FOR TERRACE
FT	FLOOR TRAP(110X110MM)
FD	FLOOR DRAIN (110X63MM)
UT	URINAL TRAP DRAIN (110X50MM)

PIPE NO.	DESCRIPTION
(1)	110 uPVC SOIL PIPE
(2)	110 uPVC WASTE PIPE
(3)	DOMESTIC COLD WATER SUPPLY PIPE
(4)	HOT WATER SUPPLY PIPE
(5)	HOT WATER RETURN PIPE
(6)	110 OD uPVC RAIN WATER PIPE
(7)	DOMESTIC WATER SUPPLY RISER PIPE

RD	Tender Docket	22-04-2024	ASM	THB
Rev.	Modification	Date	Drawn	Chkd.

CLIENT:
M/s INDIAN PORT ASSOCIATION

PROJECT TITLE
Rest House
Lodhi Road, New Delhi
India


CONSULTANT:
TAG BUILTART
Architects and Interior Design Consultants
Office No. 322, III Floor Aggarwal Square Plaza, Plot no. 9,
Pocket 7, Sector 12 Dwarka, New Delhi-110078
Mail : info@tagbuiltart.com, Mb: +91 999 919 9201
Web: www.tagbuiltart.com

MEP CONSULTANT:
 Consulting Engineers Pvt. Ltd.
H-64, Business Park (Ulfm) Sector-63, Noida-201307
Mail: hvacdesign2010@gmail.com
Mb No. : +91 971 132 3995
LEOSCOPE

DRAWING TITLE
**First Floor
Plumbing and Fire Fighting
Tender Docket**

SCALE	DRAWN	APM	DATE	PROJECT NO.
M SHEET:- 1:150	CHECKED	THB	22-04-2024	170
A3 SHEET:- 1:100				
DRAWING NO.	NORTH	REV.		
IPA-ARC-DWG-AR-1433		0		
CAD FILE REF. PLUMBING & FIRE				

- Notes :
1. This drawing is the property and copyright of M/s TAG BUILTART. It shall not be copied or used in any way without their written permission.
 2. All drawings are in Feet & Inches and to be read only and not measured.
 3. Do not scale the dimensions, follow the written dimensions unless otherwise mentioned.
 4. Contractors to verify all site conditions and any condition different or not in coherence with the drawings/details must be immediately informed to the Engineers/Architects.

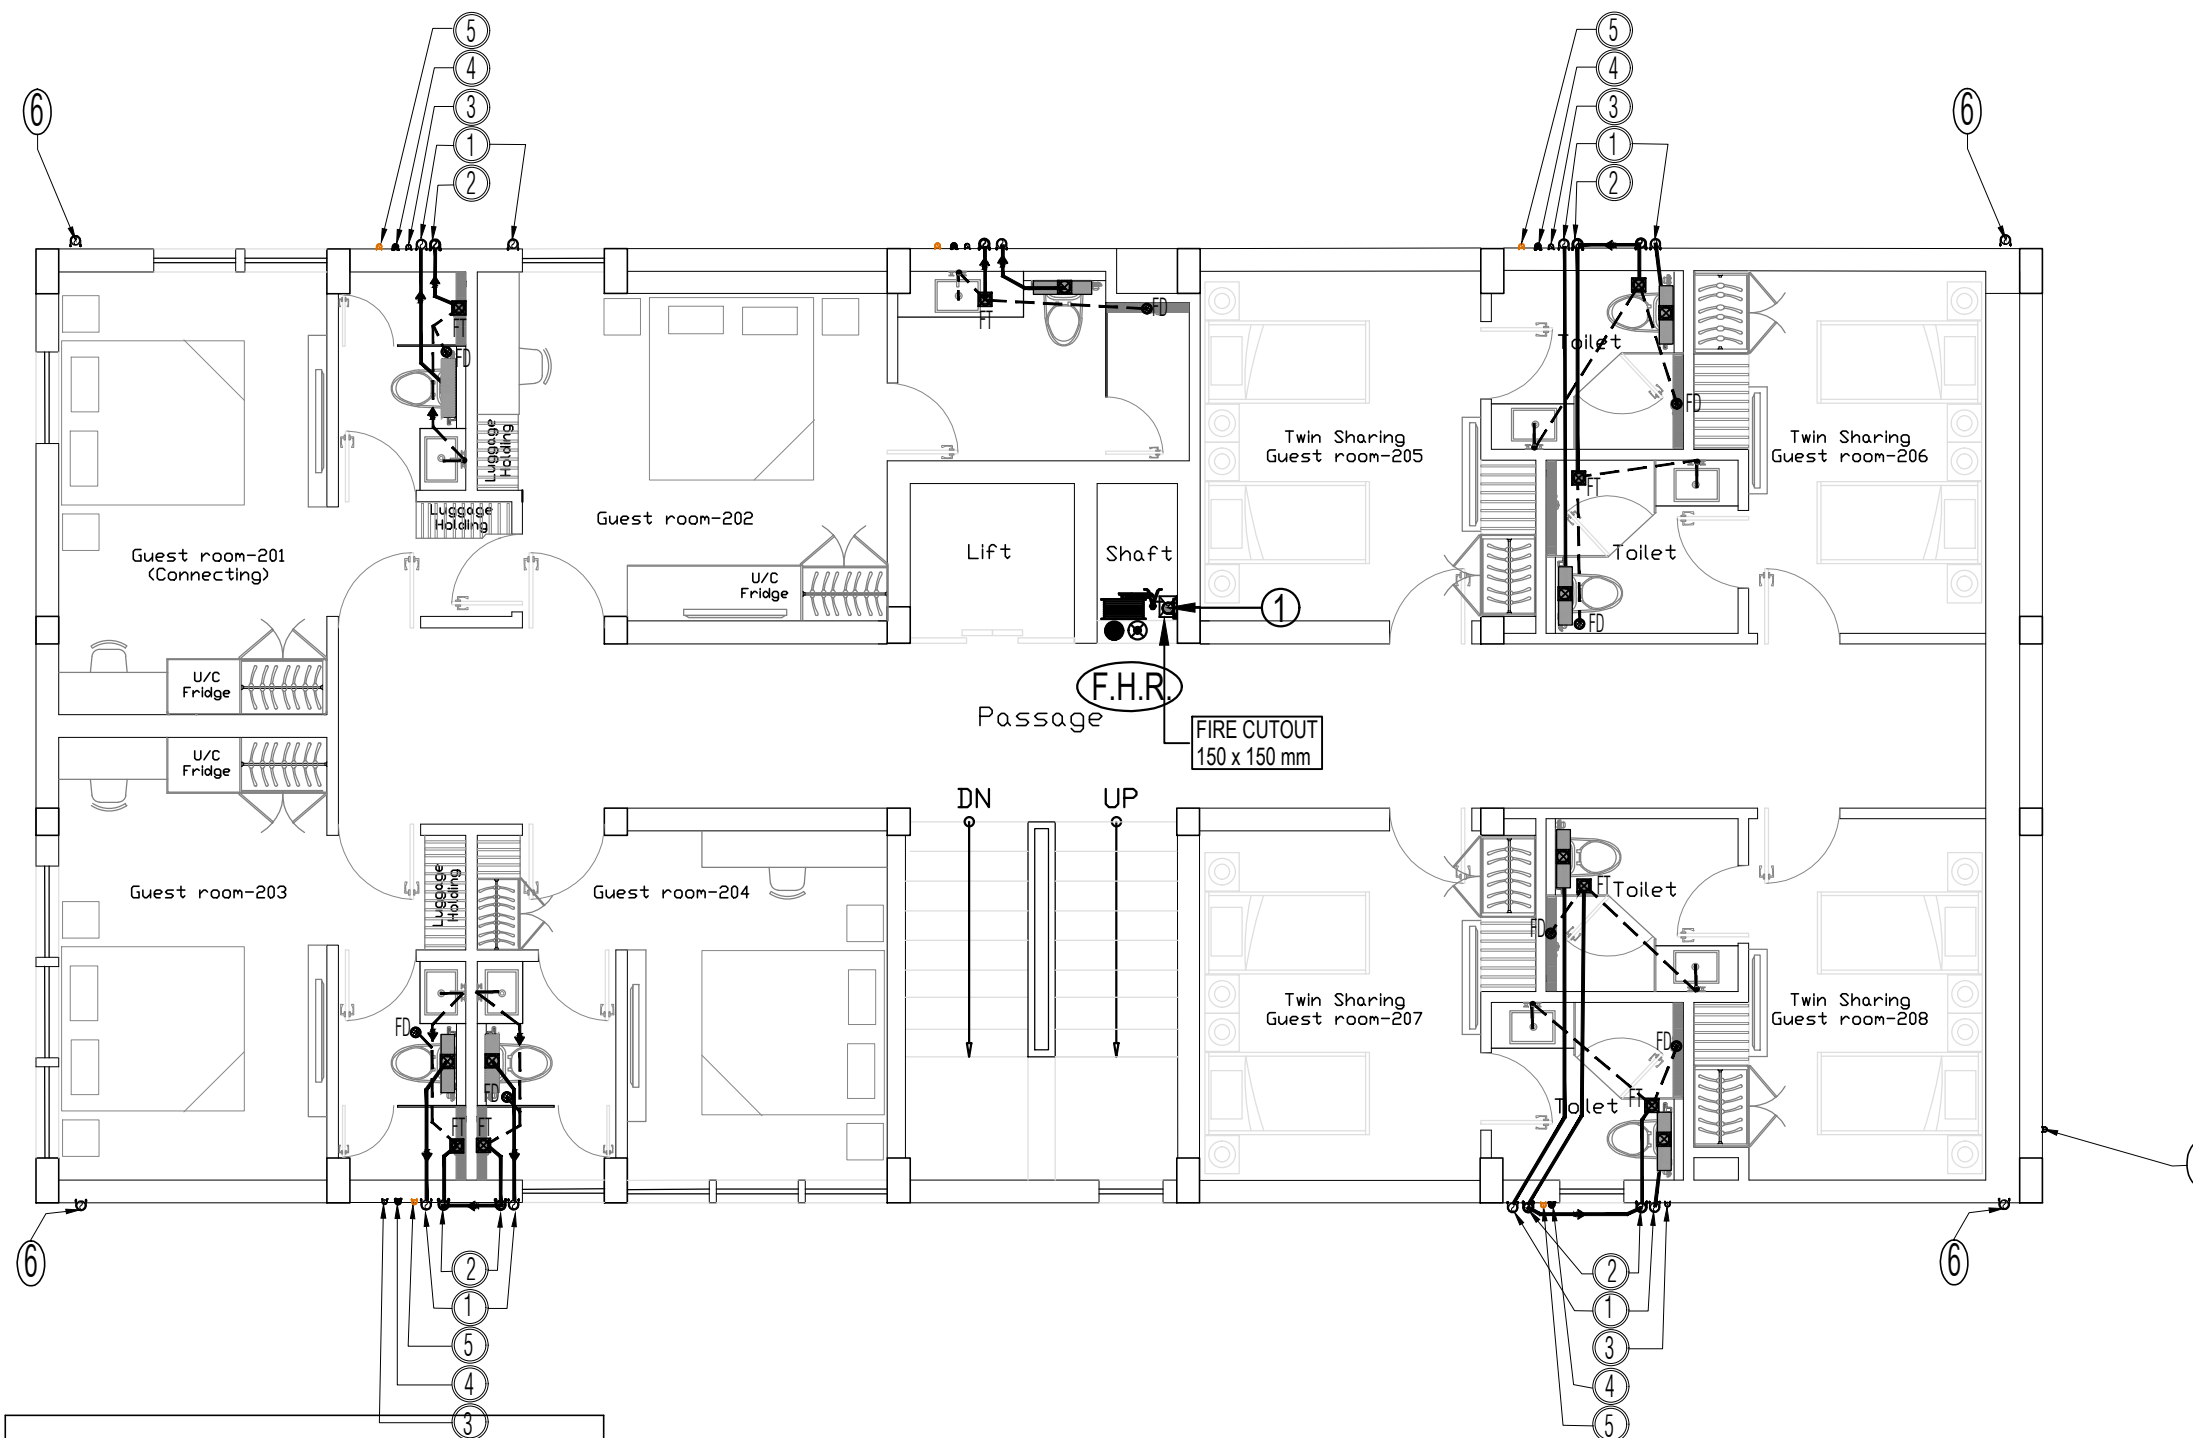

1.	WASH BASIN TO FLOOR TRAP (FT) 40 OD uPVC WASTE PIPE
2.	MULTI TRAP TO FLOOR TRAP 50 OD upvc WASTE PIPE
3.	KITCHEN SINK TO FLOOR TRAP (FT) 50 OD upvc WASTE PIPE
4.	110 OD uPVC SWR TYPE-B PIPE USED FOR SOIL & WASTE LINE.
5.	110 OD uPVC SWR TYPE-B PIPE USED FOR KITCHEN WASTE LINE.
6.	110 OD uPVC SWR TYPE-A PIPE USED FOR TERRACE
FT	FLOOR TRAP(110X110MM)
FD	FLOOR DRAIN (110X63MM)
UT	URINAL TRAP DRAIN (110X50MM)

PIPE NO.	DESCRIPTION
(1)	110 uPVC SOIL PIPE
(2)	110 uPVC WASTE PIPE
(3)	DOMESTIC COLD WATER SUPPLY PIPE
(4)	HOT WATER SUPPLY PIPE
(5)	HOT WATER RETURN PIPE
(6)	110 OD uPVC RAIN WATER PIPE
(7)	DOMESTIC WATER SUPPLY RISER PIPE

RD	Tender Docket	22-04-2024	ASM	THB
Rev.	Modification	Date	Drawn	Chkd.

CLIENT:
M/s INDIAN PORT ASSOCIATION

PROJECT TITLE
Rest House
Lodhi Road, New Delhi
India


CONSULTANT:
TAG BUILTART
Architects and Interior Design Consultants
Office No. 322, III Floor Aggarwal Square Plaza, Plot no. 9,
Pocket 7, Sector 12 Dwarka, New Delhi-110078
Mail : info@tagbuiltart.com, Mb: +91 999 919 9201
Web: www.tagbuiltart.com

MEP CONSULTANT:
LEOSCOPE
Consulting Engineers Pvt. Ltd.
H-64, Business Park (Ulfm) Sector-63, Noida-201307
Mail: hvacdesign2010@gmail.com
Mb No. : +91 971 132 3995

DRAWING TITLE
**Second Floor
Plumbing and Fire Fighting
Tender Docket**

SCALE	DRAWN	APM	DATE	PROJECT NO.
M SHEET:- 1:150	CHECKED	THB	22-04-2024	170
A3 SHEET:- 1:100				
DRAWING NO.	NORTH	REV.		
IPA-ARC-DWG-AR-1434				0
CAD FILE REF. PLUMBING & FIRE				

- Notes :
1. This drawing is the property and copyright of M/s TAG Builtart. It shall not be copied or used in any way without their written permission.
 2. All drawings are in Feet & Inches and to be read only and not measured.
 3. Do not scale the dimensions, follow the written dimensions unless otherwise mentioned.
 4. Contractors to verify all site conditions and any condition different or not in coherence with the drawings/details must be immediately informed to the Engineers/Architects.

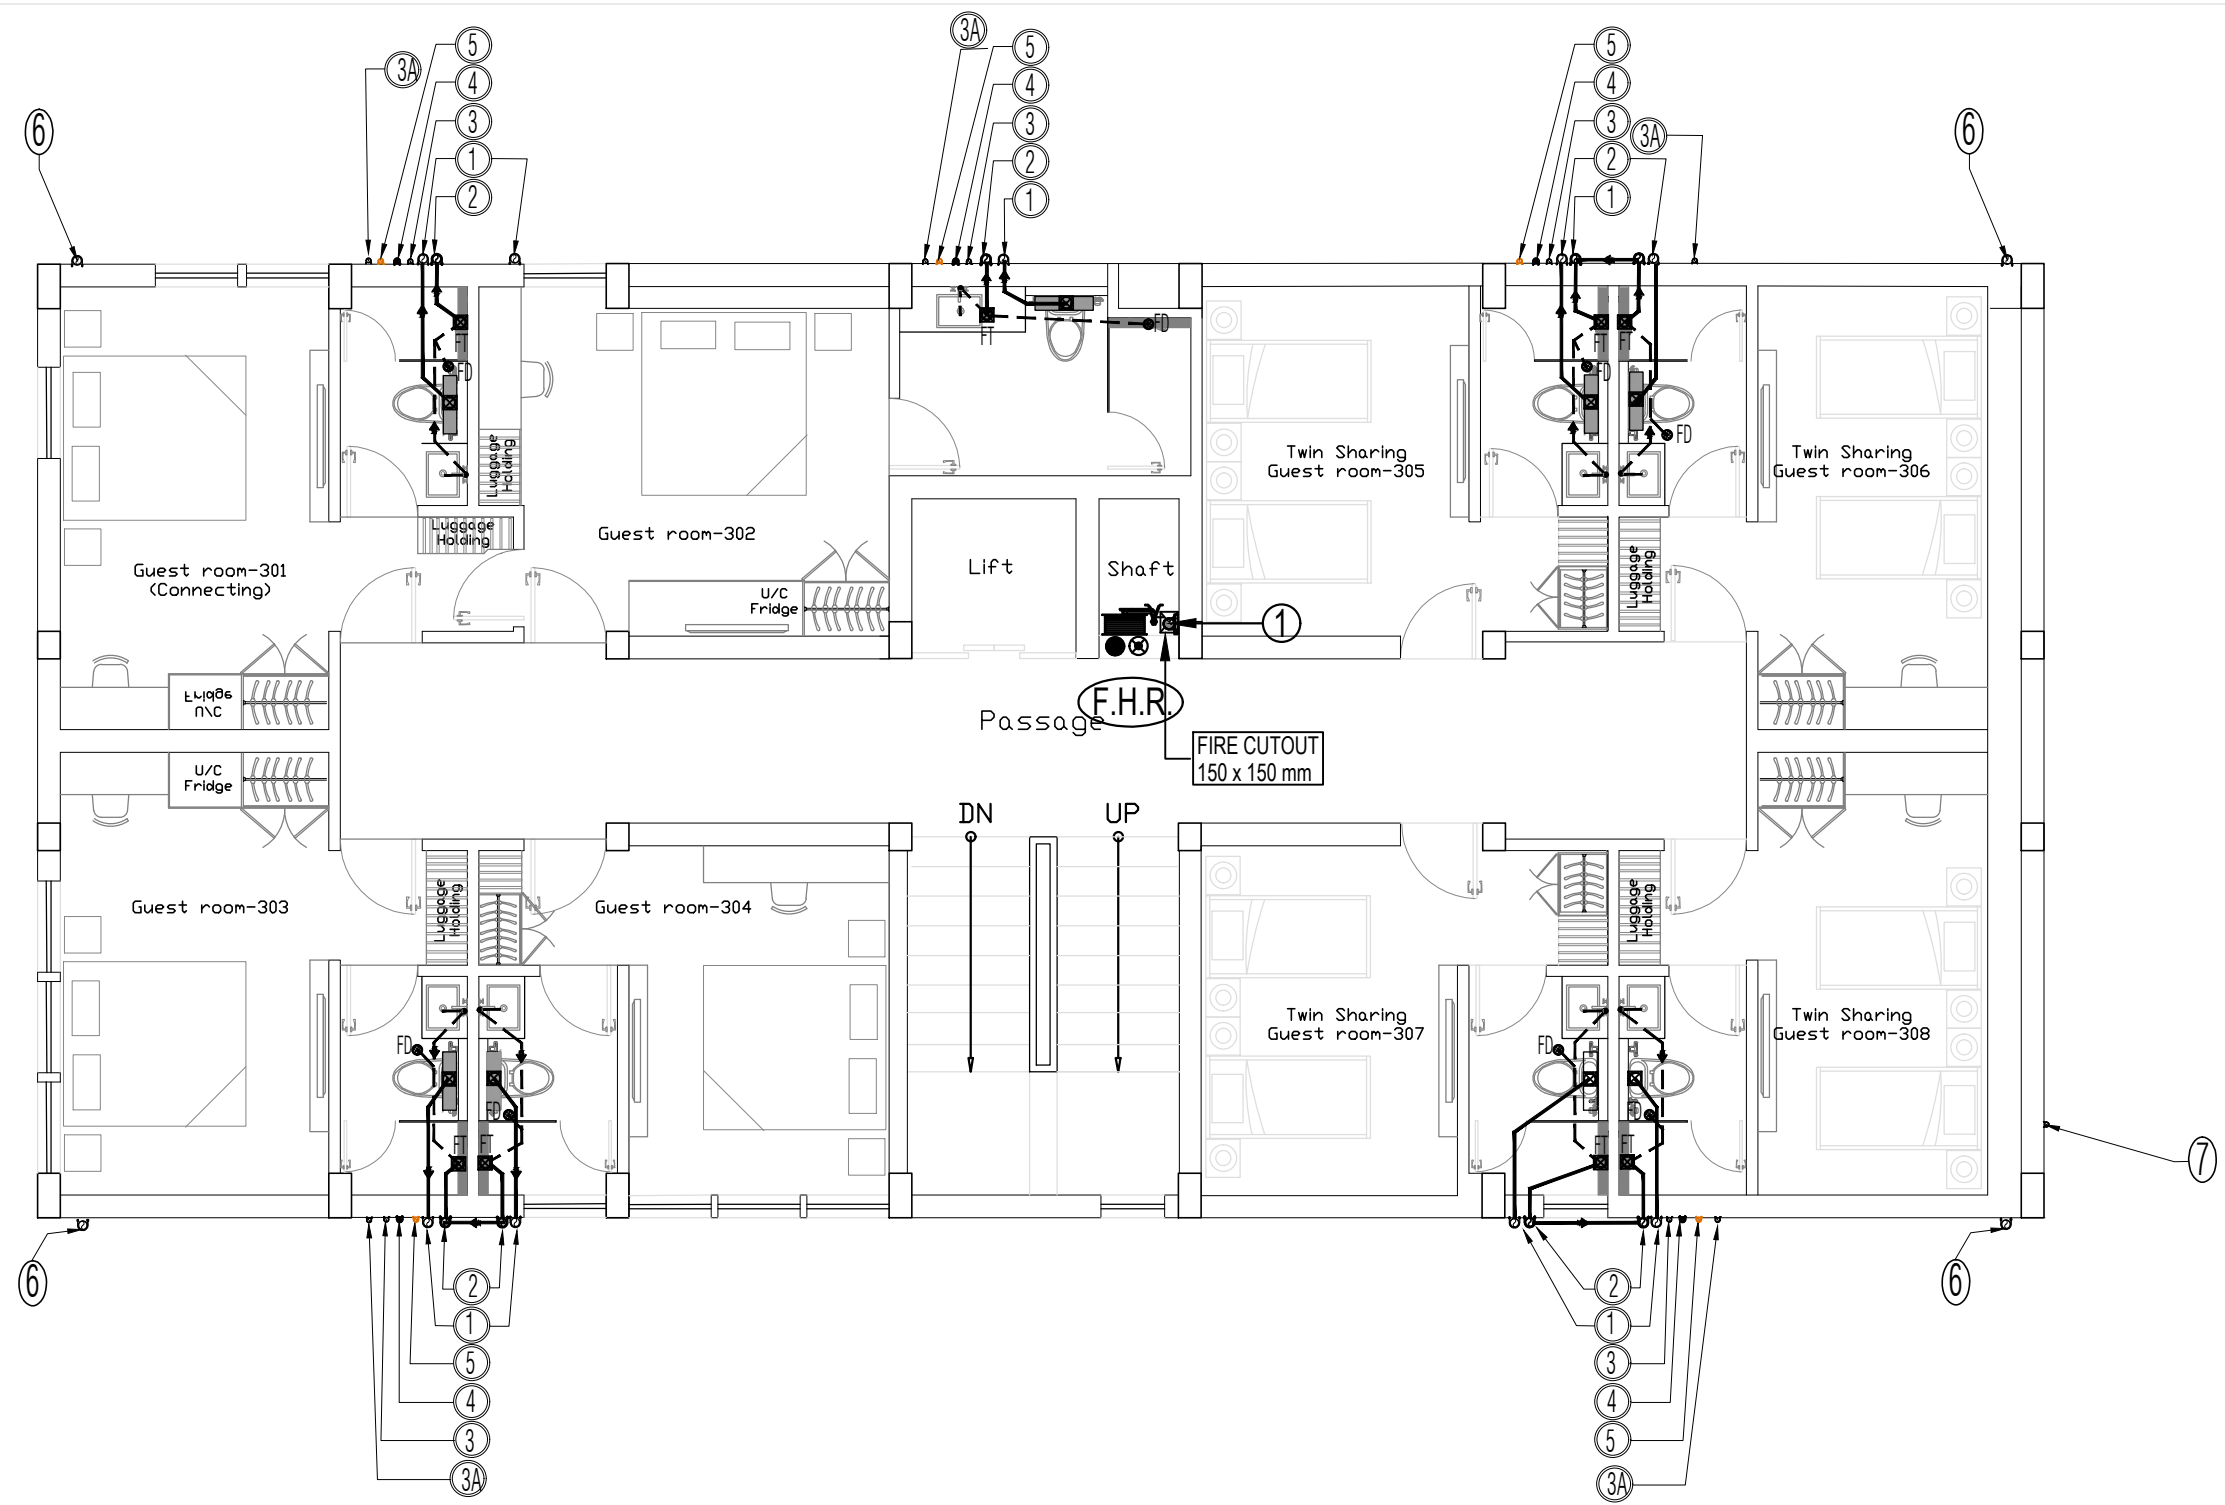

1.	WASH BASIN TO FLOOR TRAP (FT) 40 OD uPVC WASTE PIPE
2.	MULTI TRAP TO FLOOR TRAP 50 OD upvc WASTE PIPE
3.	KITCHEN SINK TO FLOOR TRAP (FT) 50 OD upvc WASTE PIPE
4.	110 OD uPVC SWR TYPE-B PIPE USED FOR SOIL & WASTE LINE.
5.	110 OD uPVC SWR TYPE-B PIPE USED FOR KITCHEN WASTE LINE.
6.	110 OD uPVC SWR TYPE-A PIPE USED FOR TERRACE
FT	FLOOR TRAP(110X110MM)
FD	FLOOR DRAIN (110X63MM)
UT	URINAL TRAP DRAIN (110X50MM)

PIPE NO.	DESCRIPTION
(1)	110 uPVC SOIL PIPE
(2)	110 uPVC WASTE PIPE
(3)	DOMESTIC COLD WATER SUPPLY PIPE
(4)	HOT WATER SUPPLY PIPE
(5)	HOT WATER RETURN PIPE
(6)	110 OD uPVC RAIN WATER PIPE
(7)	DOMESTIC WATER SUPPLY RISER PIPE

RD	Tender Docket	22-04-2024	ASM	THB
Rev.	Modification	Date	Drawn	Chkd.

CLIENT:
M/s INDIAN PORT ASSOCIATION

PROJECT TITLE
Rest House
Lodhi Road, New Delhi
India

CONSULTANT:
TAG BUILTART
Architects and Interior Design Consultants
Office No. 322, III Floor Aggarwal Square Plaza, Plot no. 9,
Pocket 7, Sector 12 Dwarka, New Delhi-110078
Mail : info@tagbuiltart.com, Mo: +91 999 919 9201
Web: www.tagbuiltart.com

MEP CONSULTANT:
 Consulting Engineers Pvt. Ltd.
H-64, Business Park (Ulfm) Sector-63, Noida-201307
Mail: hvacdesign2010@gmail.com
Mo No. : +91 971 132 3995

LEOSCOPE

DRAWING TITLE
**Third Floor
Plumbing and Fire Fighting
Tender Docket**


SCALE	DRAWN	APM	DATE	PROJECT NO.
M SHEET:- 1:150	CHECKED	THB	22-04-2024	170
A3 SHEET:- 1:100				

DRAWING NO.	NORTH	REV.
IPA-ARC-DWG-AR-1435		0

CAD FILE REF. **PLUMBING & FIRE**

Notes :

1. This drawing is the property and copyright of M/s TAG BUILTART. It shall not be copied or used in any way without their written permission.
2. All drawings are in Feet & Inches and to be read only and not measured.
3. Do not scale the dimensions, follow the written dimensions unless otherwise mentioned.
4. Contractors to verify all site conditions and any condition different or not in coherence with the drawings/details must be immediately informed to the Engineers/Architects.

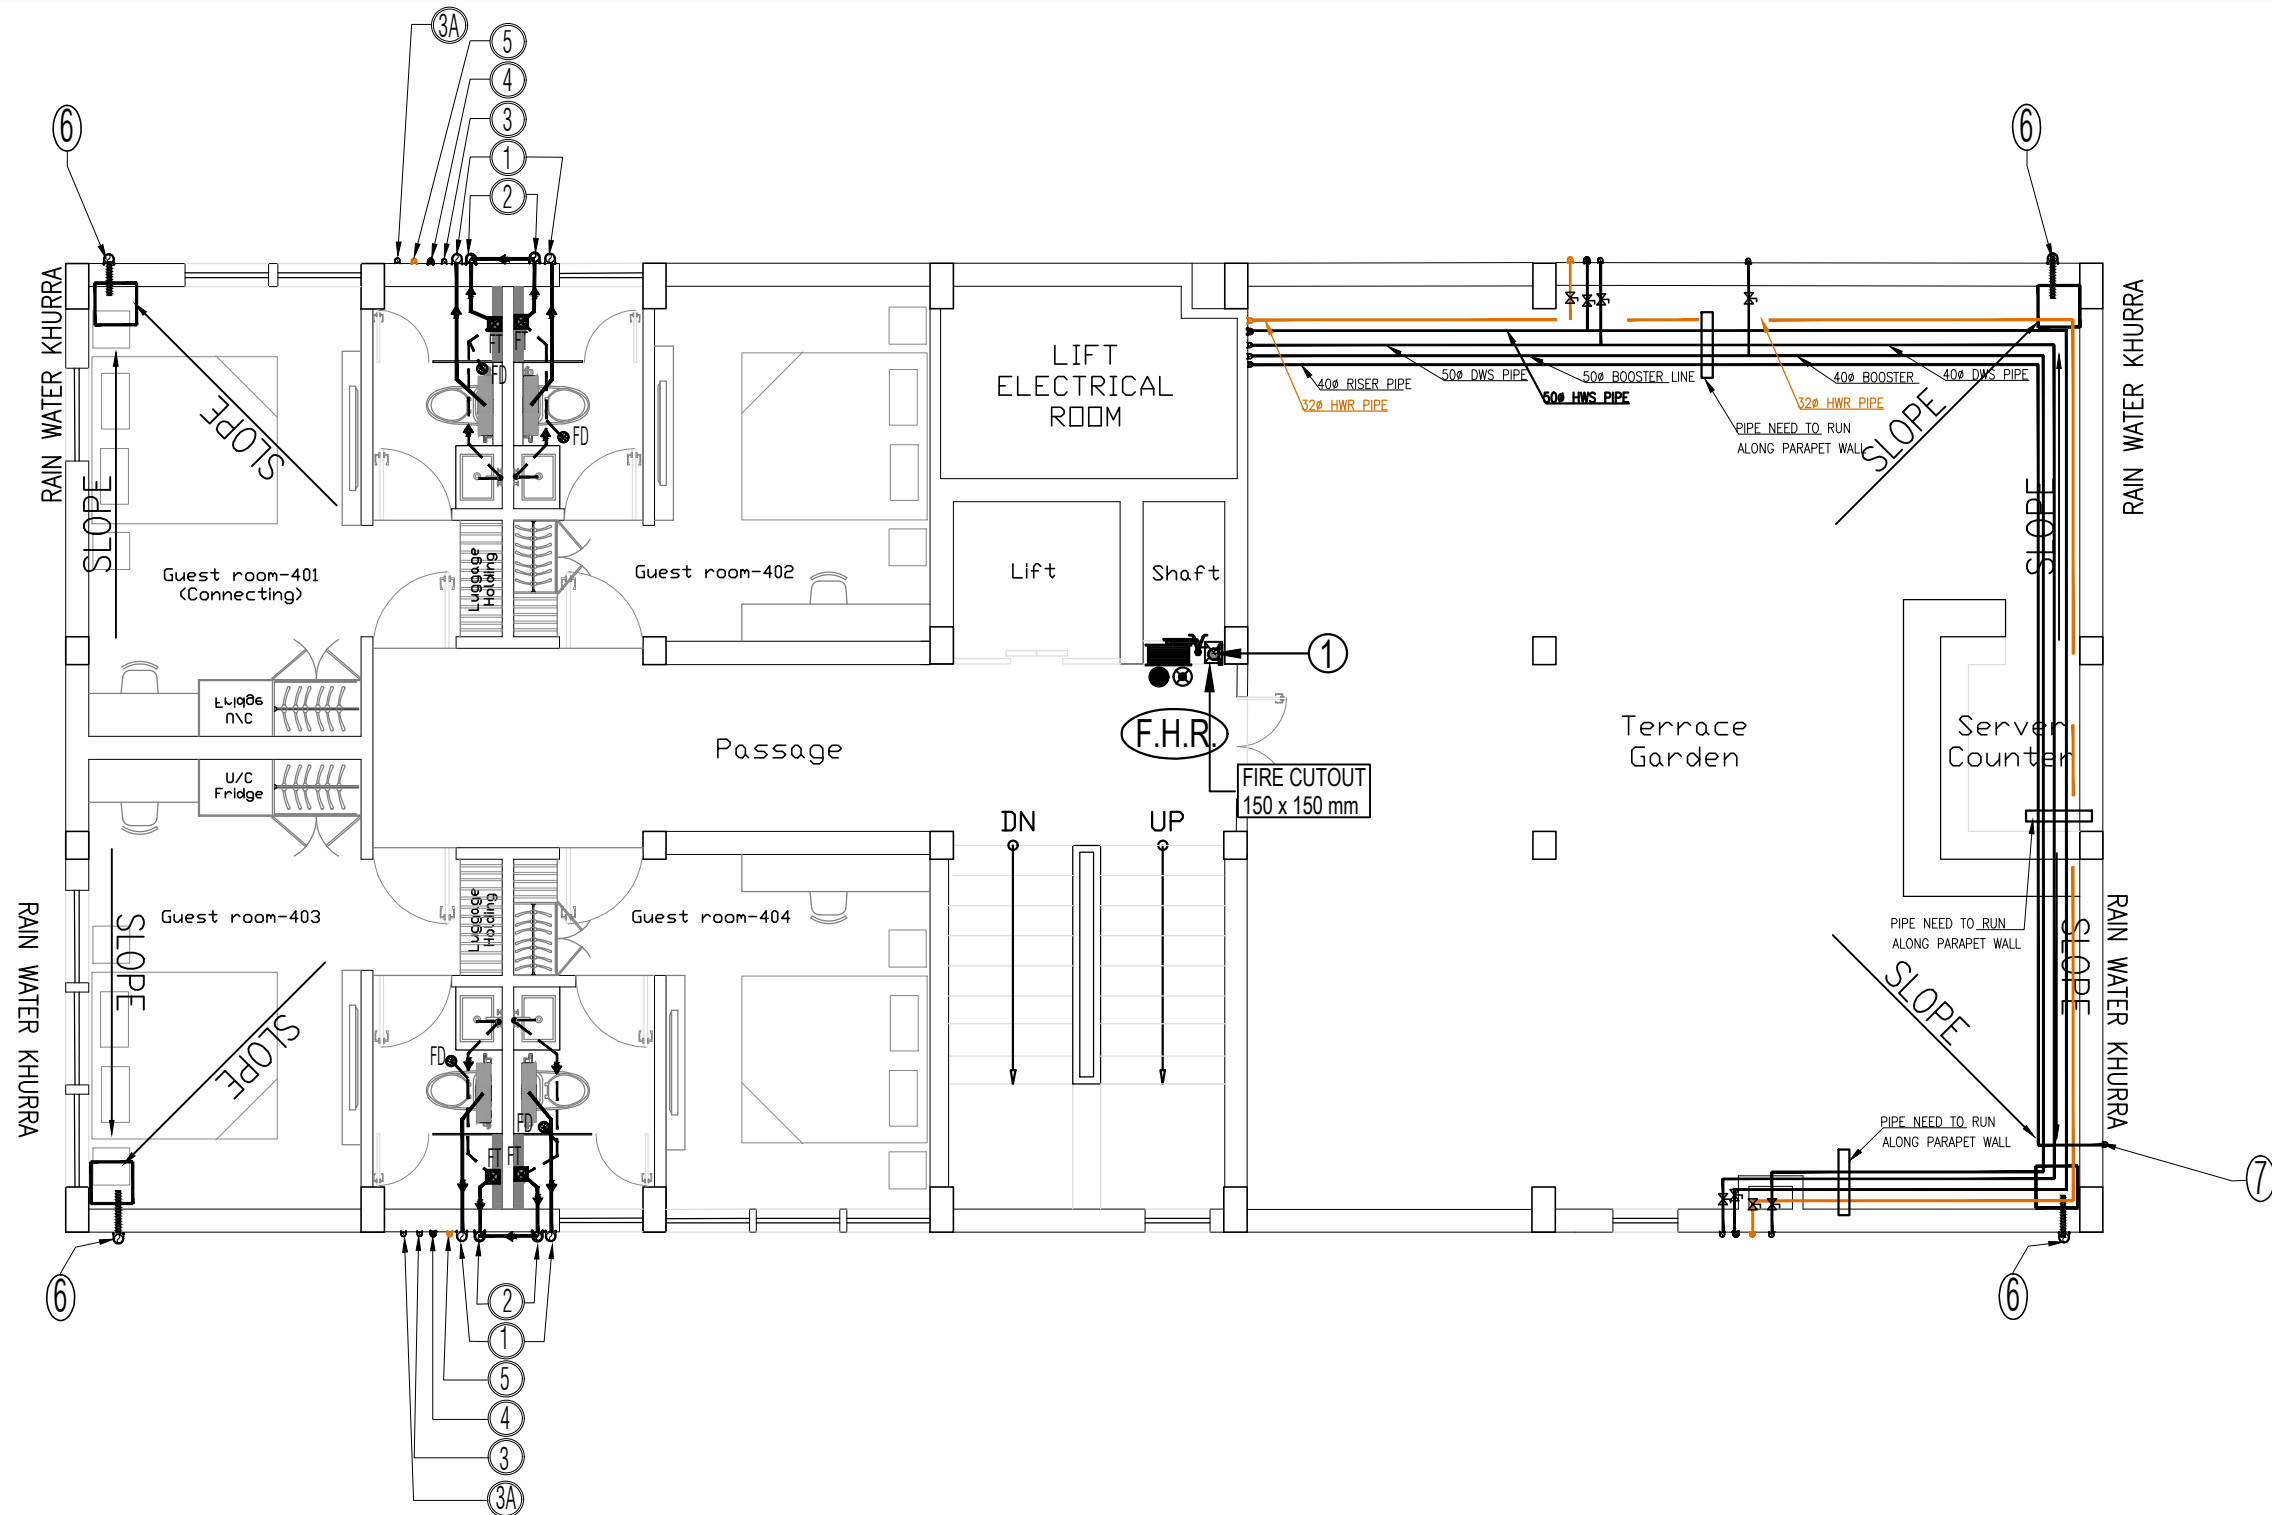

1.	WASH BASIN TO FLOOR TRAP (FT) 40 OD uPVC WASTE PIPE
2.	MULTI TRAP TO FLOOR TRAP 50 OD upvc WASTE PIPE
3.	KITCHEN SINK TO FLOOR TRAP (FT) 50 OD upvc WASTE PIPE
4.	110 OD uPVC SWR TYPE-B PIPE USED FOR SOIL & WASTE LINE.
5.	110 OD uPVC SWR TYPE-B PIPE USED FOR KITCHEN WASTE LINE.
6.	110 OD uPVC SWR TYPE-A PIPE USED FOR TERRACE
FT	FLOOR TRAP(110X110MM)
FD	FLOOR DRAIN (110X63MM)
UT	URINAL TRAP DRAIN (110X50MM)

SCHEDULE OF PIPES	
PIPE NO.	DESCRIPTION
(1)	110 uPVC SOIL PIPE
(2)	110 uPVC WASTE PIPE
(3)	DOMESTIC COLD WATER SUPPLY PIPE
(4)	HOT WATER SUPPLY PIPE
(5)	HOT WATER RETURN PIPE
(6)	110 OD uPVC RAIN WATER PIPE
(7)	DOMESTIC WATER SUPPLY RISER PIPE

Rev.	Tender Docket	22-04-2024	ASM	THB
Rev.	Modification	Date	Drawn	Chkd.

CLIENT:
M/s INDIAN PORT ASSOCIATION


PROJECT TITLE
Rest House
Lodhi Road, New Delhi
India

CONSULTANT:
TAG BUILTART
Architects and Interior Design Consultants.
Office No. 322, III Floor Aggarwal Square Plaza, Plot no. 9,
Pocket 7, Sector 12 Dwarka, New Delhi-110078
Mail: info@tagbuiltart.com, Mb: +91 999 919 9201
Web: www.tagbuiltart.com

MEP CONSULTANT:
LEOSCOPE
Consulting Engineers Pvt. Ltd.
H-64, Business Park (Uffim) Sector-63, Noida-201307
Mail: hvacdesign2010@gmail.com
Mb No. : +91 971 132 3995

DRAWING TITLE
Fourth Floor
Plumbing and Fire Fighting
Tender Docket

SCALE	DRAWN	APM	DATE	PROJECT NO.
M SHEET:- 1:150	CHECKED	THB	22-04-2024	170
A3 SHEET:- 1:100				
DRAWING NO.	NORTH	REV.		
IPA-ARC-DWG-AR-1436		0		
CAD FILE REF. PLUMBING & FIRE				

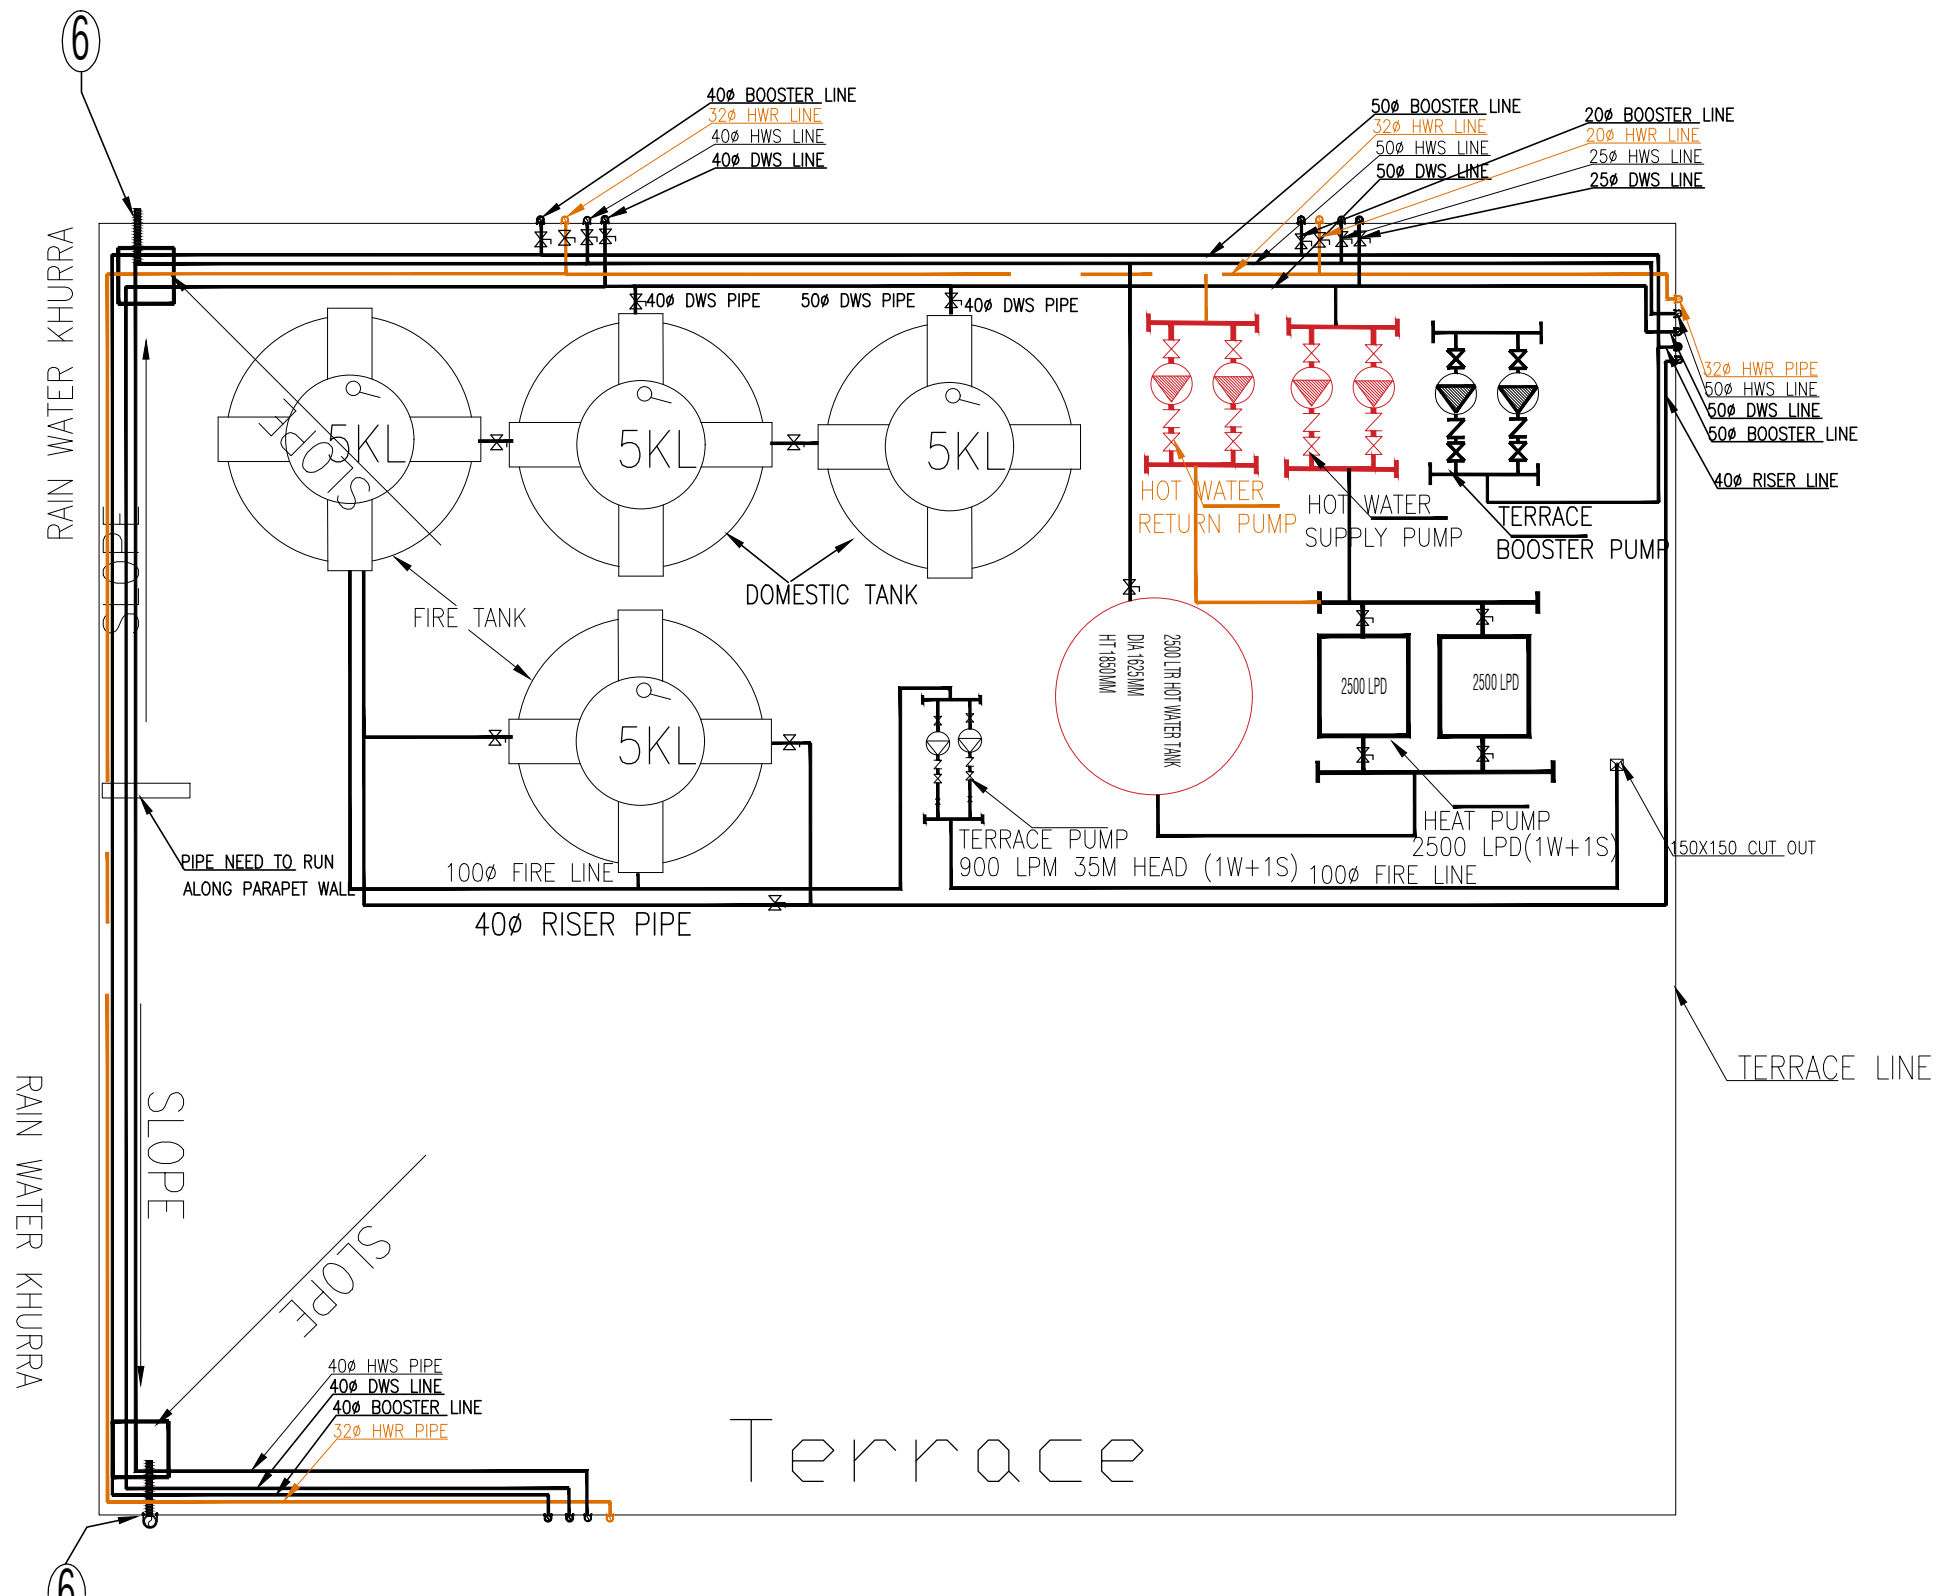

Notes :

1. This drawing is the property and copyright of M/s TAG Builtart. It shall not be copied or used in any way without their written permission.
2. All drawings are in Feet & Inches and to be read only and not measured.
3. Do not scale the dimensions, follow the written dimensions unless otherwise mentioned.
4. Contractors to verify all site conditions and any condition different or not in coherence with the drawings/details must be immediately informed to the Engineers/Architects.

Rev.	Modification	Date	Drawn	Chkd.

CLIENT:
M/s INDIAN PORT ASSOCIATION

PROJECT TITLE
Rest House
Lodhi Road, New Delhi
India

CONSULTANT:
TAG BUILTART
Proficiency and Interior Design Consultants
Office No. 322, III Floor Aggarwal Square Plaza, Plot no. 9,
Pocket 7, Sector 12 Dwarka, New Delhi-110078
Mail: info@tagbuiltart.com, Mb: +91 999 919 9201
Web: www.tagbuiltart.com

MEP CONSULTANT:
LEOSCOPE
Consulting Engineers Pvt. Ltd.
H-64, Business Park (Uffim) Sector-63, Noida-201307
Mail: hvacdesign2010@gmail.com
Mb No. : +91 971 132 3995

DRAWING TITLE
Terrace Floor
Plumbing and Fire Fighting
Tender Docket

SCALE	DRAWN	APM	DATE	PROJECT NO.
M SHEET:- 1:150	CHECKED	THB	22-04-2024	170
A3 SHEET:- 1:100				
DRAWING NO.	NORTH	REV.		
IP-A-ARC-DWG-AR-1437		0		
CAD FILE REF. PLUMBING & FIRE				

1.	WASH BASIN TO FLOOR TRAP (FT) 40 OD uPVC WASTE PIPE
2.	MULTI TRAP TO FLOOR TRAP 50 OD upvc WASTE PIPE
3.	KITCHEN SINK TO FLOOR TRAP (FT) 50 OD upvc WASTE PIPE
4.	110 OD uPVC SWR TYPE-B PIPE USED FOR SOIL & WASTE LINE.
5.	110 OD uPVC SWR TYPE-B PIPE USED FOR KITCHEN WASTE LINE.
6.	110 OD uPVC SWR TYPE-A PIPE USED FOR TERRACE
FT	<input checked="" type="checkbox"/> FLOOR TRAP(110X110MM)
FD	<input checked="" type="checkbox"/> FLOOR DRAIN (110X63MM)
UT	<input checked="" type="checkbox"/> URINAL TRAP DRAIN (110X50MM)

PIPE NO.	DESCRIPTION
(1)	110 uPVC SOIL PIPE
(2)	110 uPVC WASTE PIPE
(3)	DOMESTIC COLD WATER SUPPLY PIPE
(4)	HOT WATER SUPPLY PIPE
(5)	HOT WATER RETURN PIPE
(6)	110 OD uPVC RAIN WATER PIPE
(7)	DOMESTIC WATER SUPPLY RISER PIPE